


FIRST FLOOR PLAN
SCALE: 1/4" = 1'-0"

INSTALL 4" CONC. SLAB WITH 6 X 6, W
1.4 X W 1.4 WWF OVER 6 MIL POLY. VB
AND 4" CRUSHED STONE- TYP.


INSTALL 1 1/2" RIGID PERIMETER
INSULATION- TYP.

INSTALL HVAC SYSTEM AS REQ'D AND
DIRECTED ABOVE ACT CEILING. LOCATE
HVAC AS REQ'D ON TOP OF RESTROOM

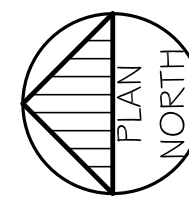


FIRST FLOOR FIXTURE PLAN
SCALE: 1/4" = 1'-0"

NEW WALLS

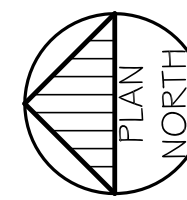





FIRST FLOOR ELECTRICAL PLAN
SCALE: 1/4" = 1'-0"

OUTLET LOCATIONS AS DIRECTED BY
OWNER.
E = EGRESS LIGHT

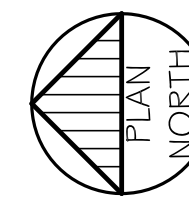

FIRST FLOOR EGRESS PLAN
SCALE: 1/4" = 1'-0"

EGRESS PATH

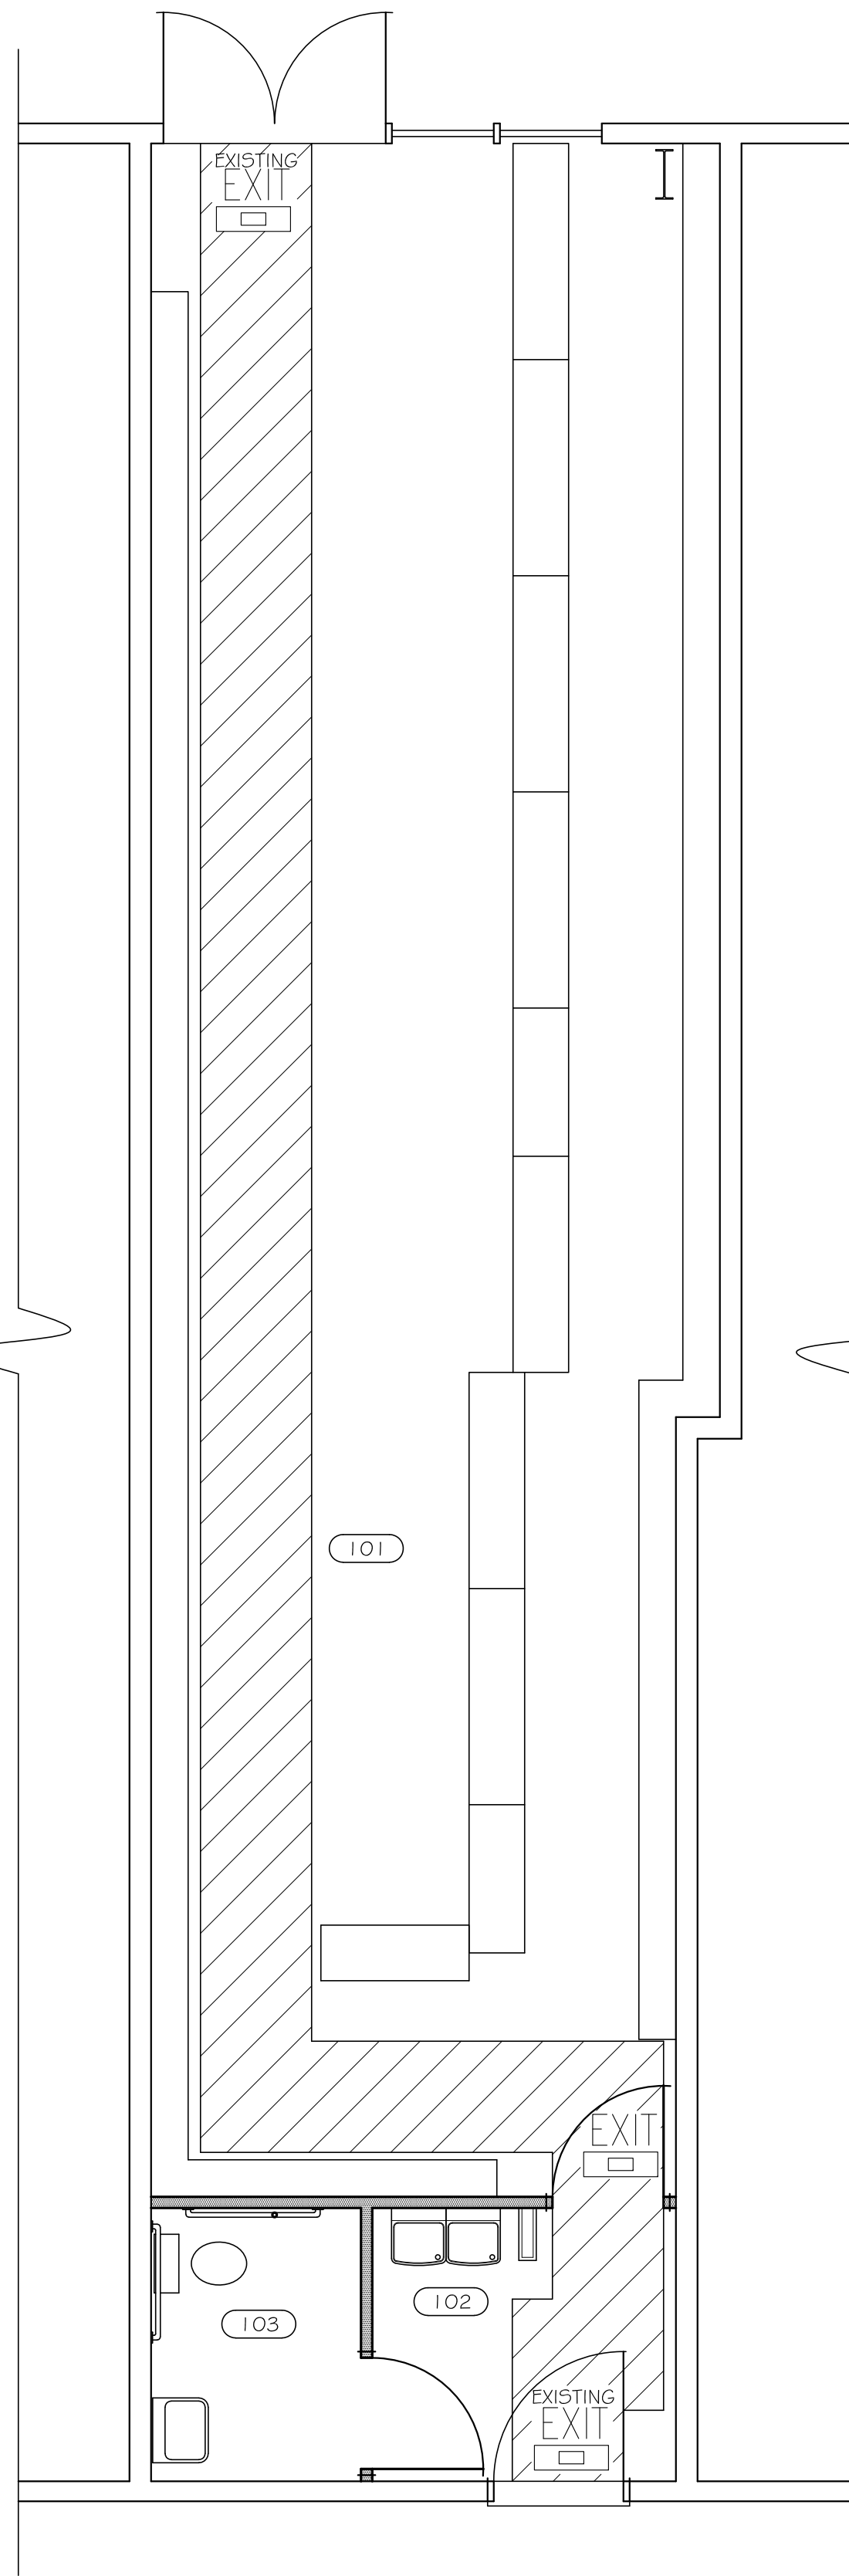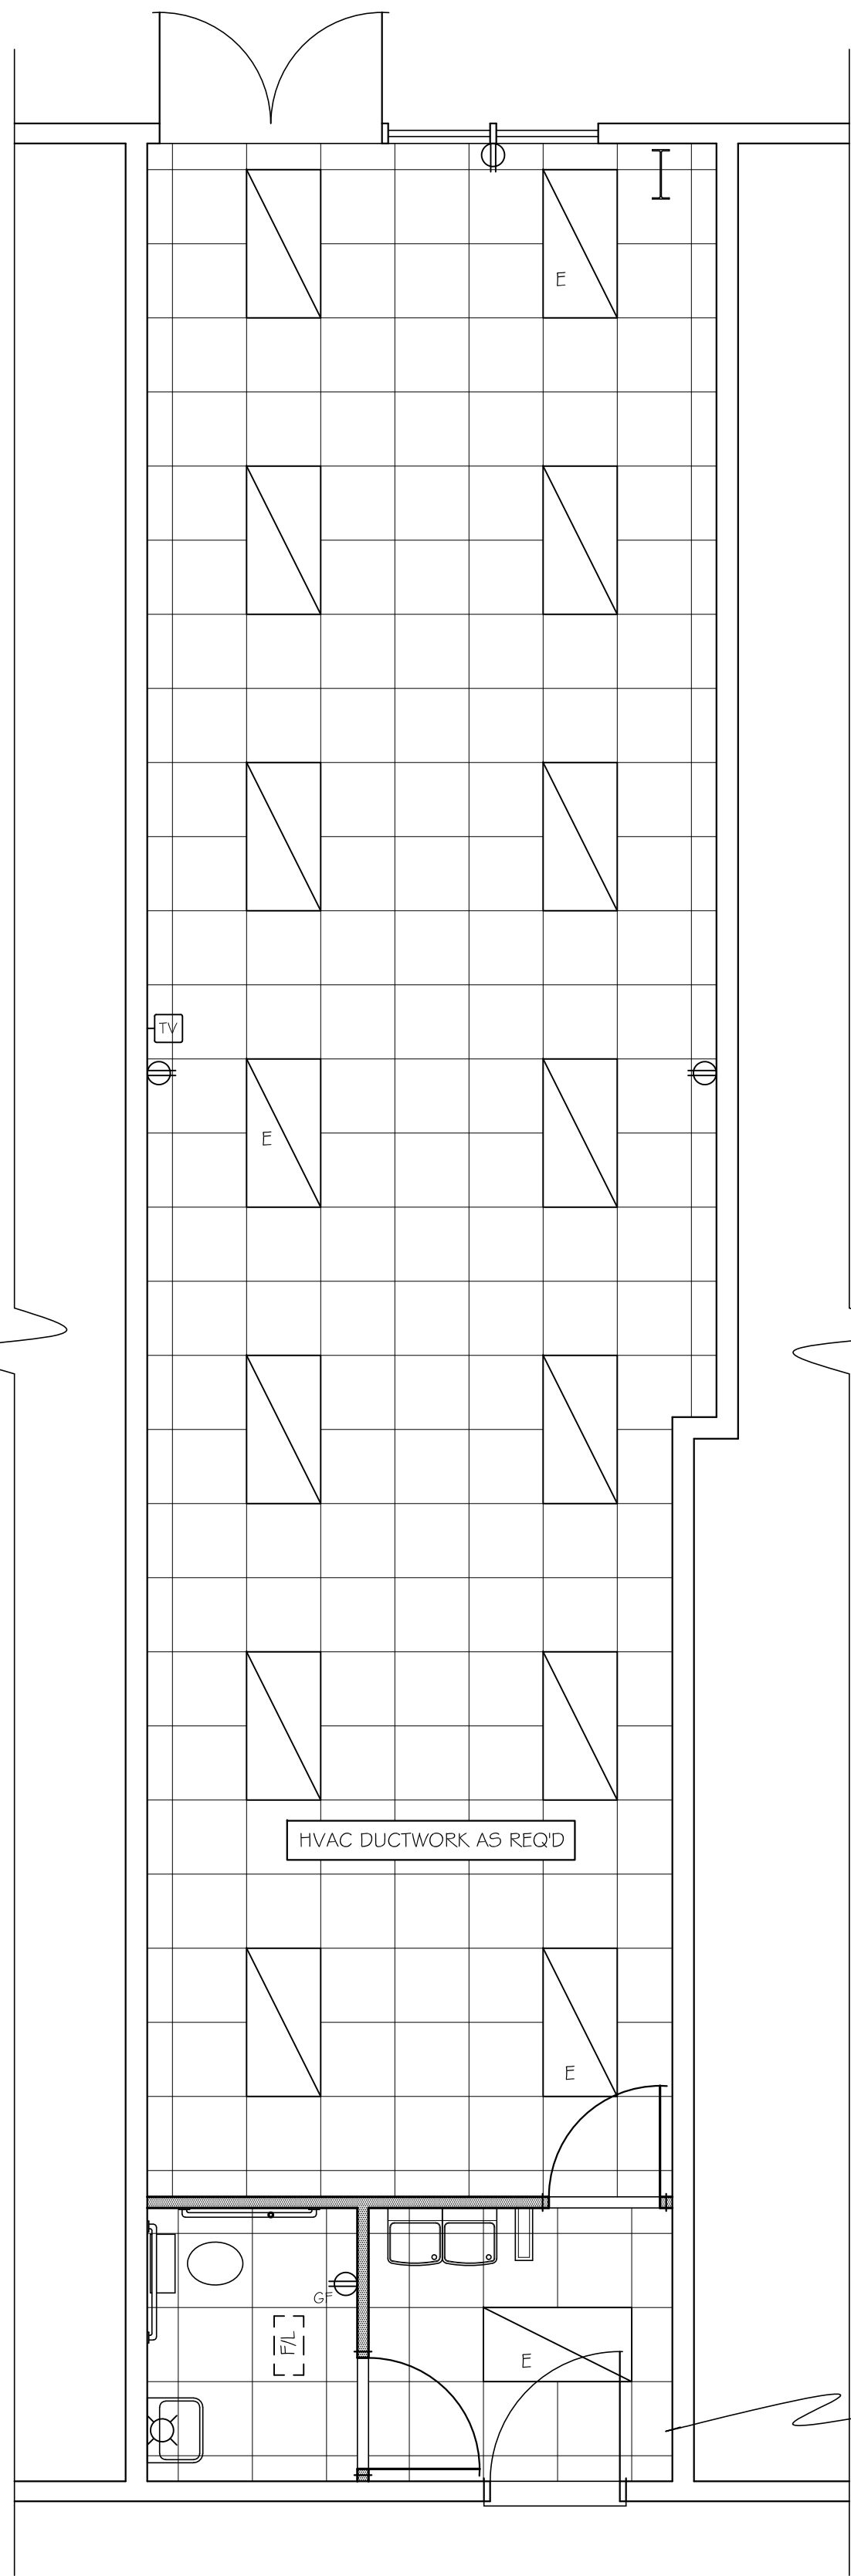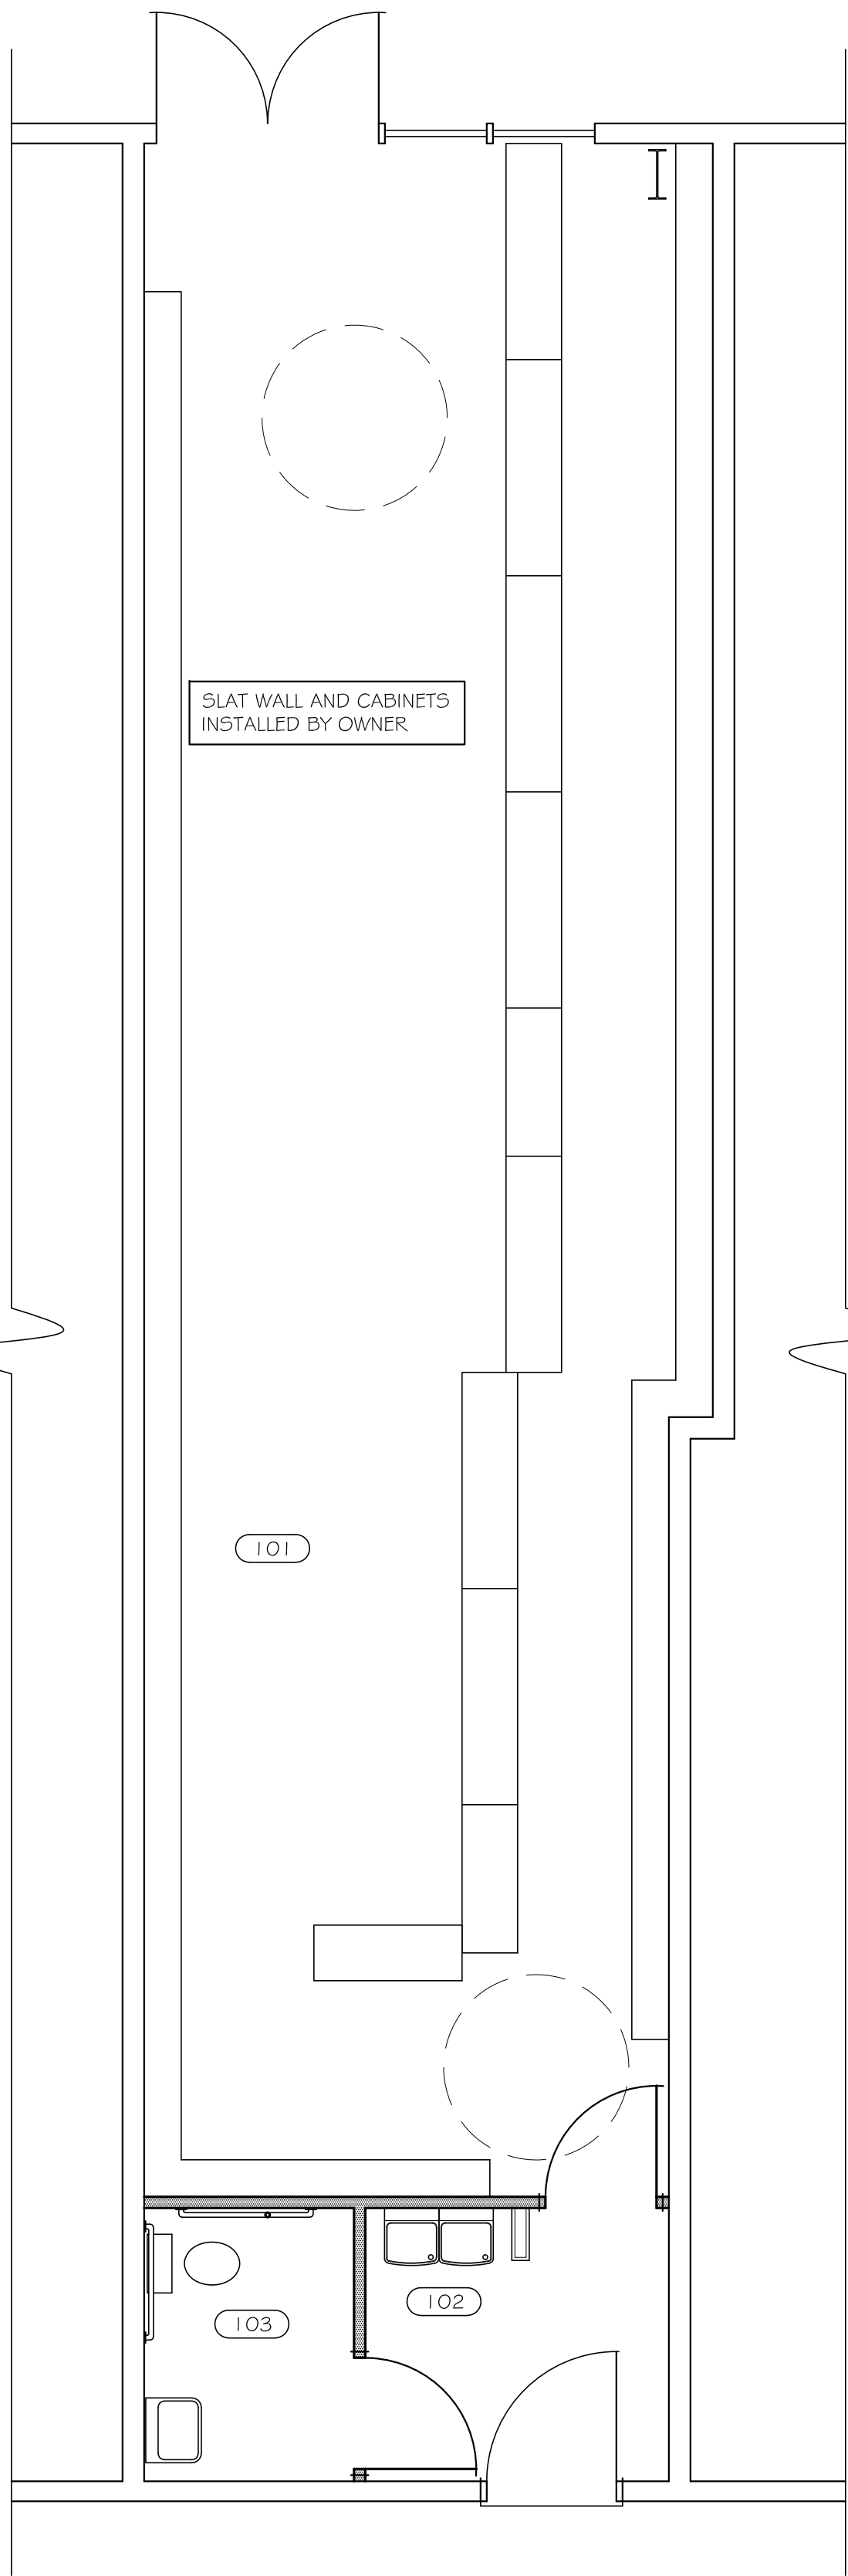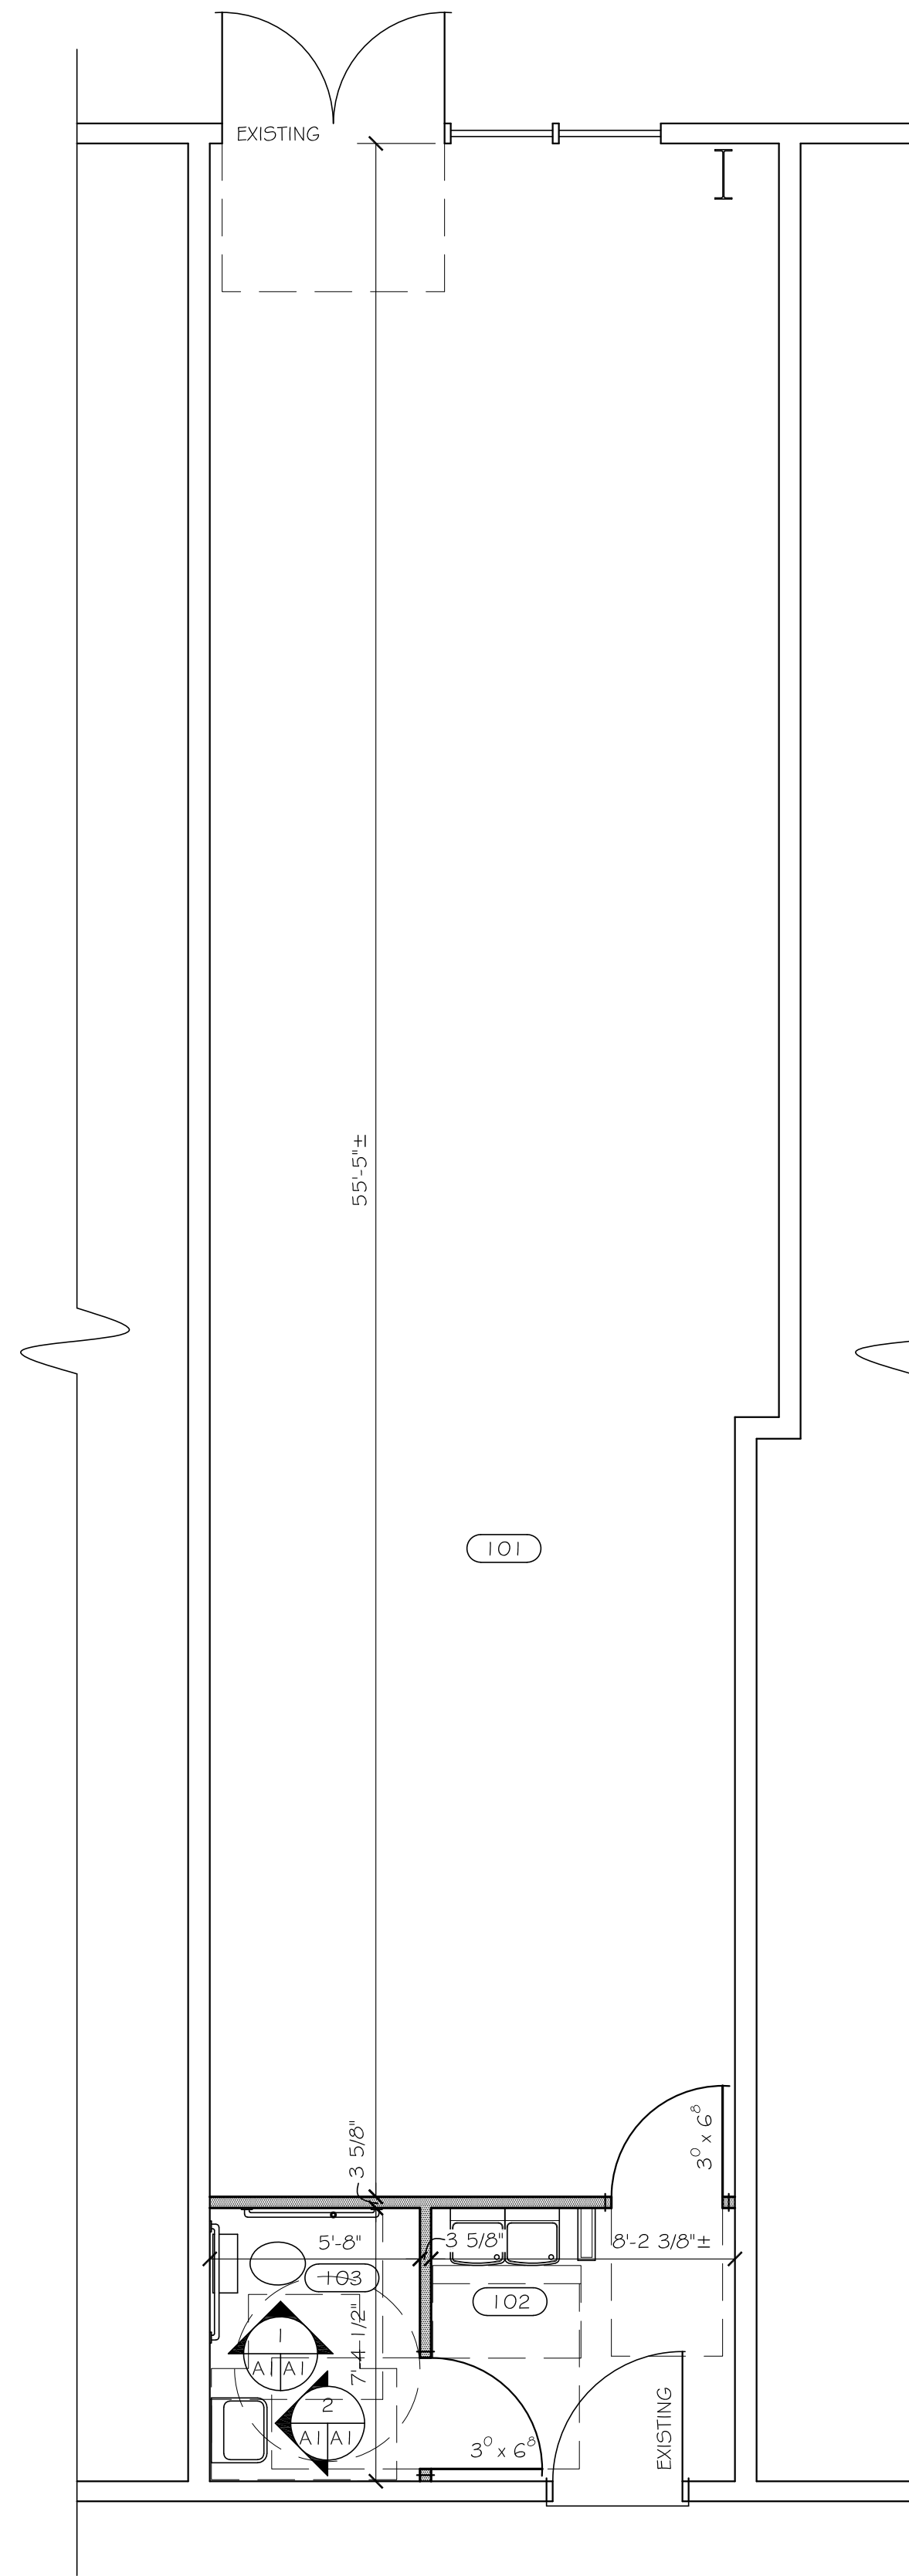

PROGRESS PRINTS



NOT FOR CONSTRUCTION USE

RETAIL SPACE RENOVATION FOR
NEO TOBACCO & VAPE
GREENE COUNTY, VIRGINIA

JOB NO:
2129
DATE:
8-1-21
DRAWN:
JHM SMB


A 1

REVISIONS
PLANS
GAINES GROUP
ARCHITECTS

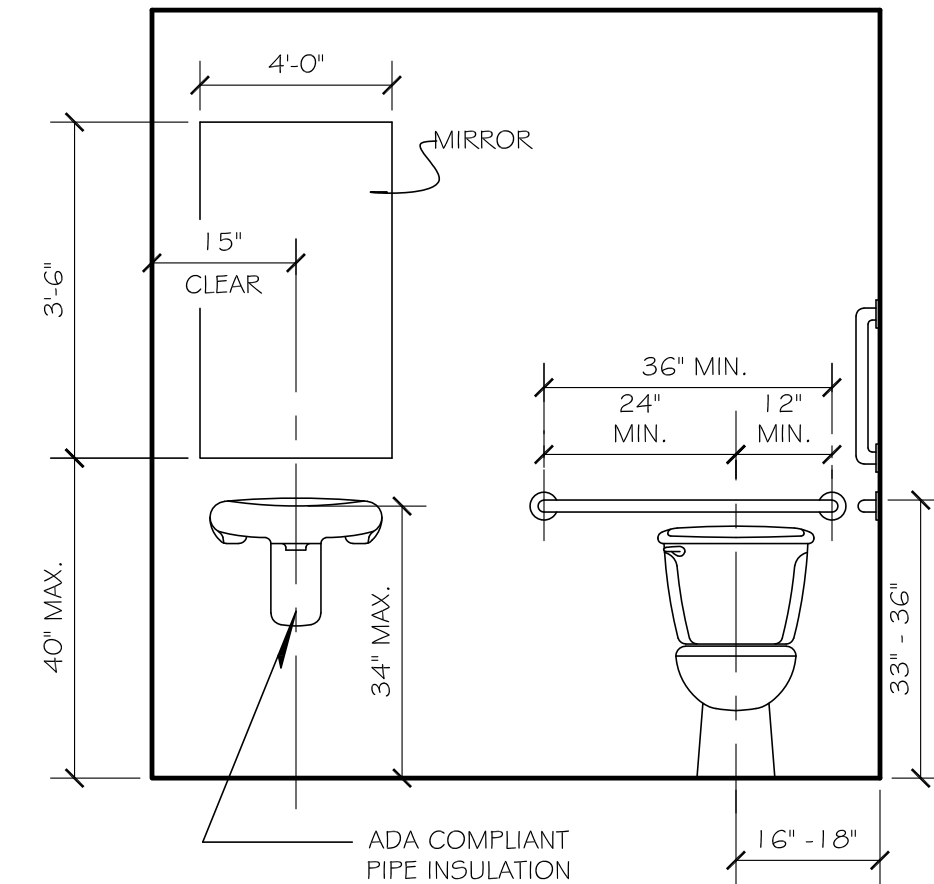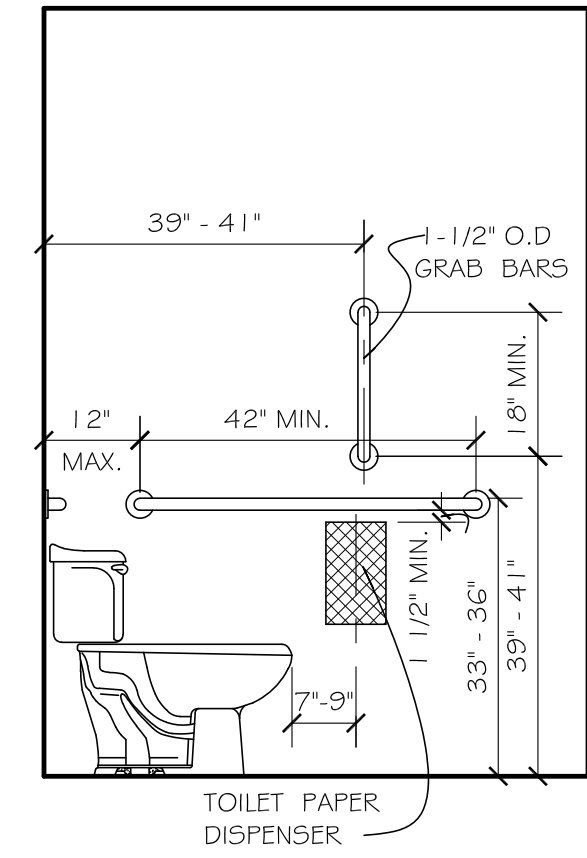

2

SCALE: 1/2" = 1'-0"

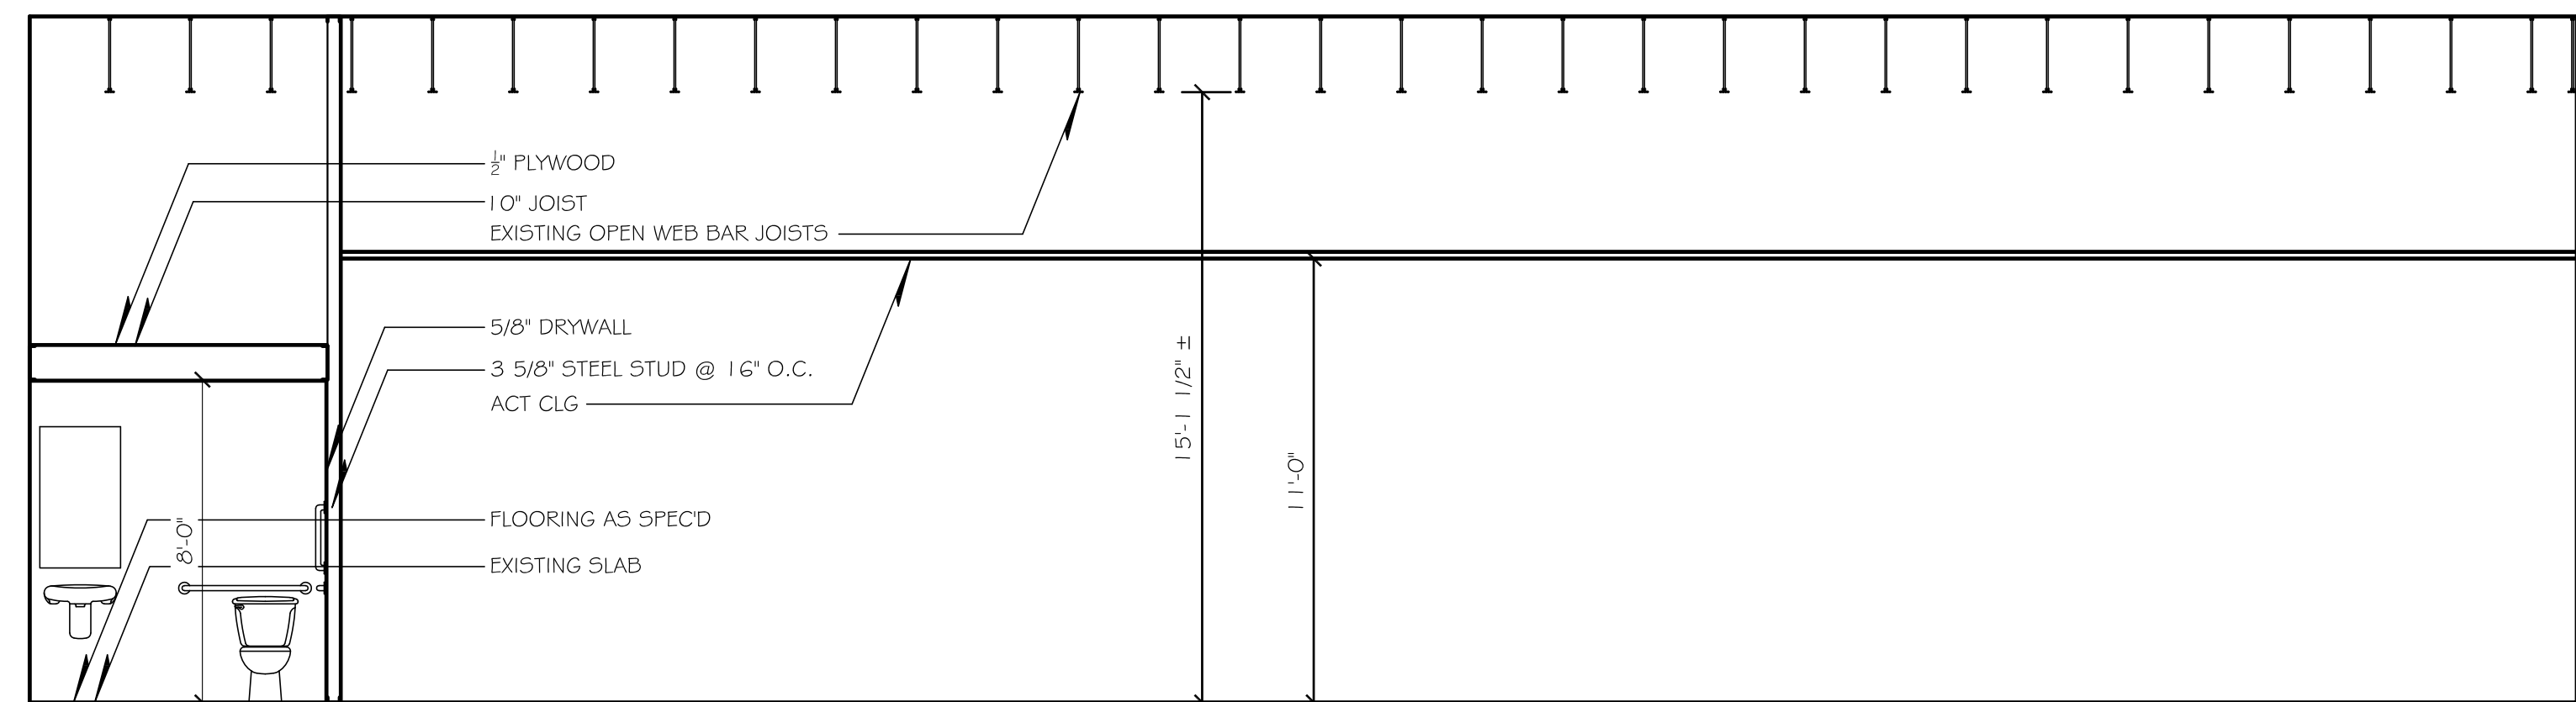

PROGRESS PRINTS
NOT FOR CONSTRUCTION USE