

Tivoli Farm - Garage

Gordonsville,VA

INDEX OF DRAWINGS					RELEASE HISTORY		
SHEET	SHEET NAME	RELEASE	REVISION	REMARKS	ID	ISSUE NAME	DATE
A-000	TITLE SHEET & INDEX OF DRAWINGS		01	03	01	Preliminary Pricing	1/13/2023 3:41 PM
A-001	SITE PLAN		02	05, 14	02	Construction Documents	2/6/2023 3:44 PM
A-100	SELECTIVE REMOVALS		02	05			
A-200	PLANS		02	07, 13			
A-300	EXTERIOR ELEVATIONS		02				
A-310	BUILDING SECTIONS		02	06, 11, 13			
A-320	WALL SECTIONS		02	06, 08, 12			
A-330	EXTERIOR DETAILS		02				
A-400	SCHEDULES AND TRIM PROFILES		02				
A-410	GARAGE DOOR DETAILS		02	06, 10			
S/E-200	FIRST FLOOR STRUCTURAL & ELECTRICAL		02	09			

CHANGE INDEX		
ID	DESCRIPTION	Last Modified date
01	Site Plan	1/10/2023 7:57 AM
02	Floor Plan	1/10/2023 8:01 AM
03	Elevations	1/10/2023 8:04 AM
04	Sections	1/10/2023 8:07 AM
05	Extended Parking	1/31/2023 3:38 PM
06	Turned Down Slab	1/31/2023 3:40 PM
07	Concrete Finish	1/30/2023 10:52 AM
08	Exterior Trim Finish	1/31/2023 3:43 PM
09	Car Charger	1/30/2023 11:05 AM
10	Apron Detail	1/31/2023 3:44 PM
11	Truss Details	1/31/2023 4:44 PM
12	Structural Details	2/3/2023 4:33 PM
13	Hatch R.O.	2/6/2023 2:55 PM
14	FF Spot Elevations	2/6/2023 3:21 PM



CONSTRUCTION DOCUMENTS

DALGLIESH
GILPIN
PAXTON

ARCHITECTS

Approved:

Tivoli Farm - Garage
9171 Tivoli Drive
Gordonsville, VA

TITLE SHEET & INDEX OF DRAWINGS
CONSTRUCTION DOCUMENTS

Revisions

Release	Date
01	1/13/2023


Job #	Date
4504.1	06 FEB 2023
Drawn	Checked
DRG	EWA

CONTRACTOR TO VERIFY ALL DIMENSIONS AT SITE AND SHALL NOTIFY ARCHITECT OF ANY DISCREPANCIES BEFORE PROCEEDING

© 2021 Dalgliesh Gilpin Paxton Architects

A-000

PRINTED 2/8/2023, 4:11 PM

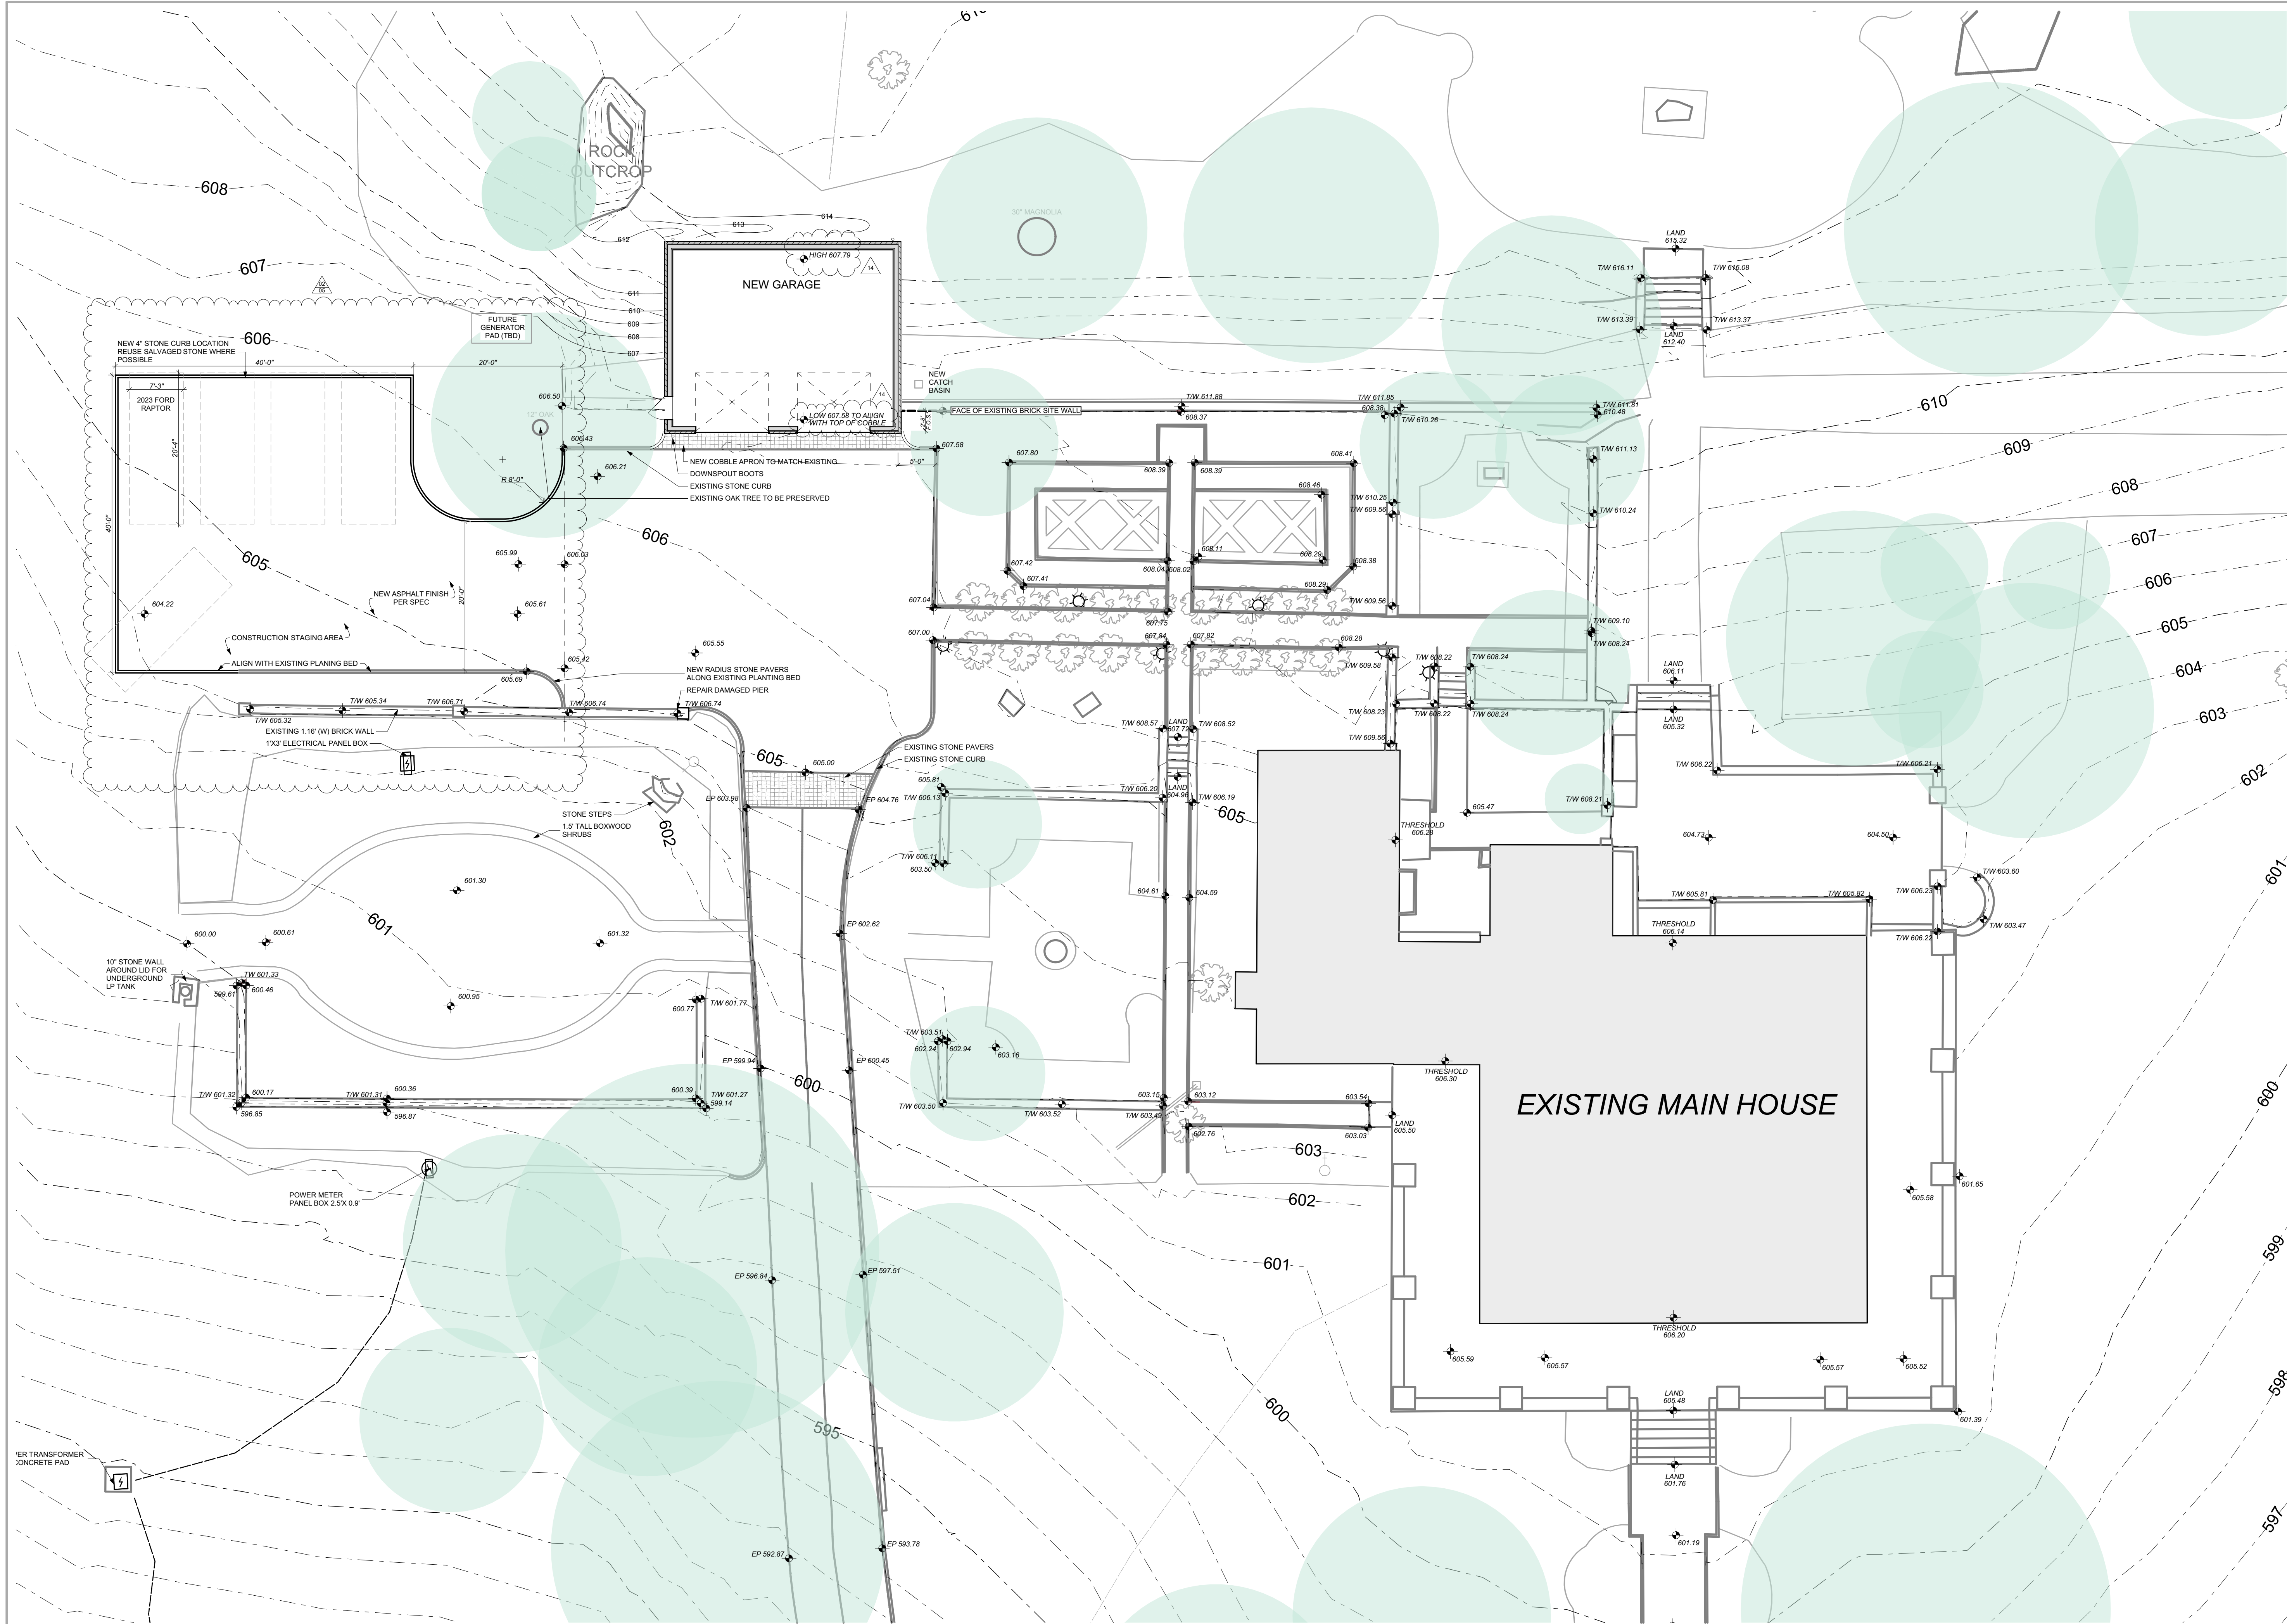

TIVOLI FARM - GARAGE - SITE PLANS

KEY

TO BE DEMOLISHED

EXISTING TO REMAIN

NEW BUILDING CONSTRUCTION

GENERAL

1. NO DETERMINATION WAS MADE AS TO THE EXISTENCE OR LOCATION OF UNDERGROUND UTILITIES. CALL MISS UTILITY (811) BEFORE ANY GROUND DISTURBING ACTIVITIES.

2. LANDSCAPE PLANS PROVIDED BY RUSTY LILY

WORK POINT

NORTH

DALGLIESH
GILPIN
PAXTON
ARCHITECTS

Approved:

Tivoli Farm - Garage
9171 Tivoli Drive
Gordonsville, VA

SITE PLAN
CONSTRUCTION DOCUMENTS


Revisions	
Release	Date
01	1/13/2023
02	2/6/2023

Job #	Date
4504.1	08 FEB 2023
Drawn	Checked
DRG	EWA
CONTRACTOR TO VERIFY ALL DIMENSIONS AT SITE AND SHALL NOTIFY ARCHITECT OF ANY DISCREPANCIES BEFORE PROCEEDING	

© 2021 Dalgliesh Gilpin Paxton Architects

A-001

PRINTED 2/6/2023, 4:48 PM

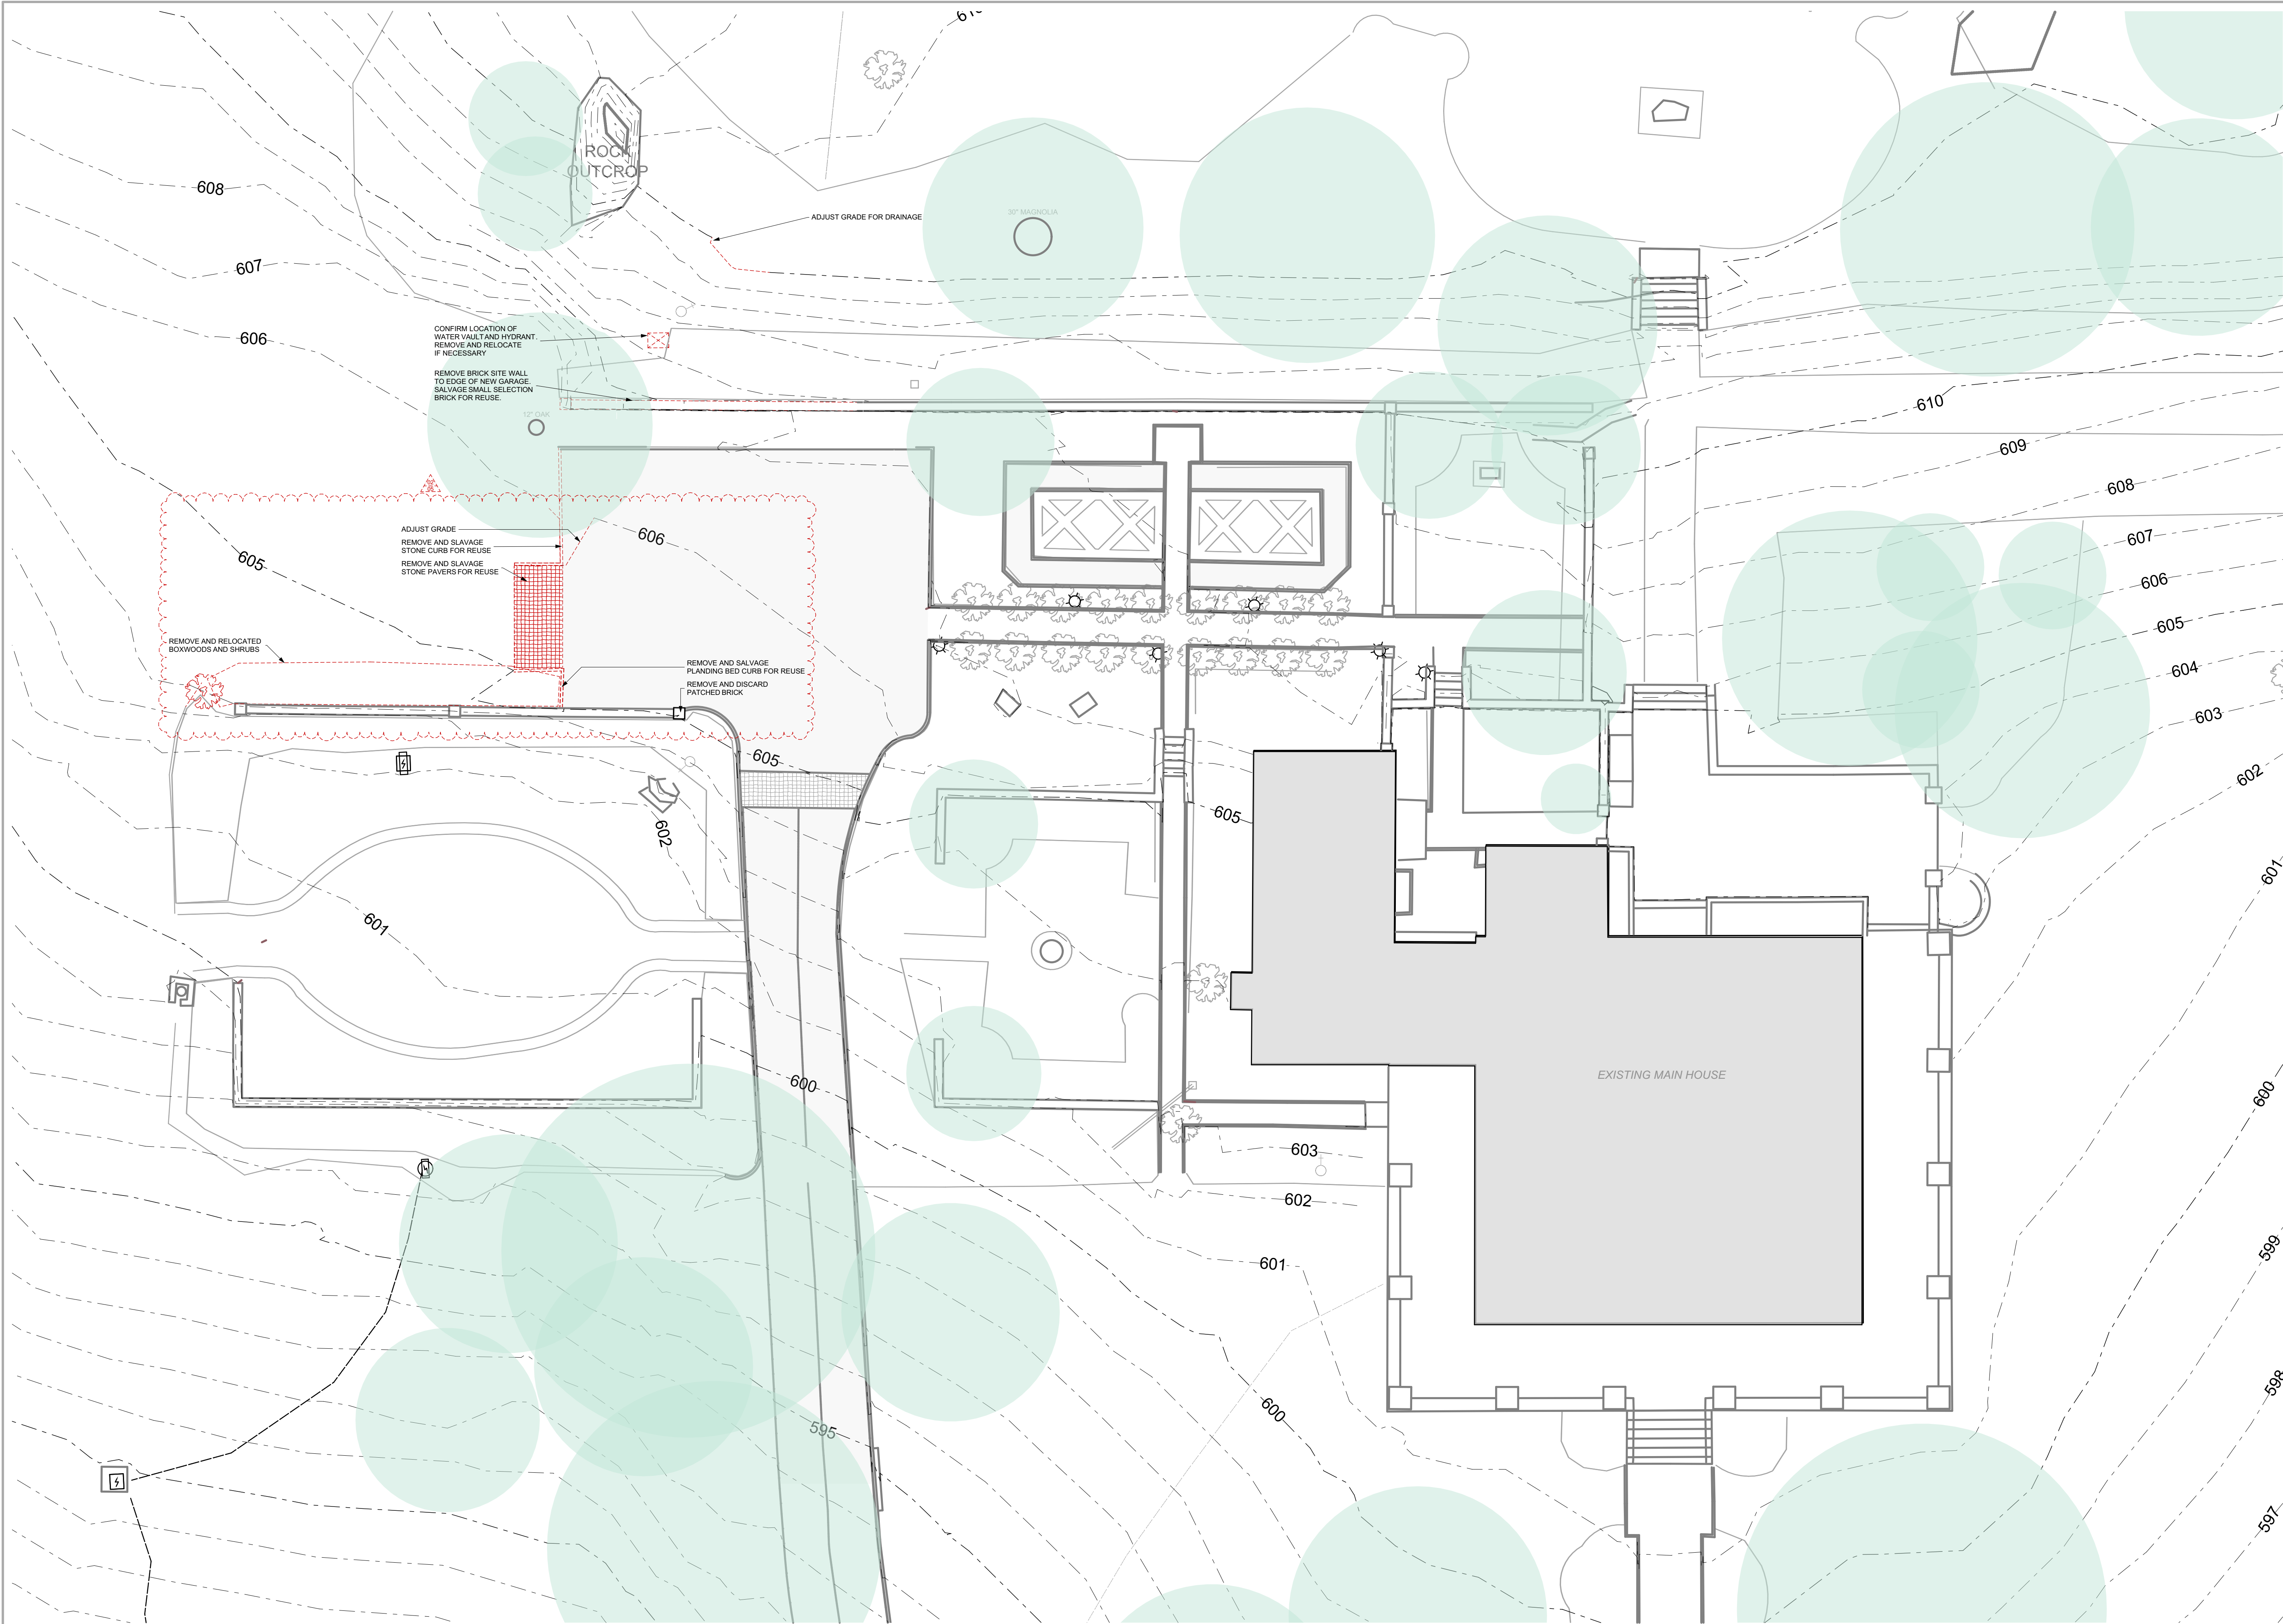

1 SELECTIVE REMOVALS

SCALE: 1" = 10'

Approved:

Tivoli Farm - Garage
9171 Tivoli Drive
Gordonsville, VA

SELECTIVE REMOVALS
CONSTRUCTION DOCUMENTS


Revisions

Release	Date
01	1/19/2023
02	2/6/2023


Job #	Date
4504.1	06 FEB 2023
Drawn	Checked
DRG	EWA

CONTRACTOR TO VERIFY ALL DIMENSIONS AT SITE AND SHALL NOTIFY ARCHITECT OF ANY DISCREPANCIES BEFORE PROCEEDING


© 2021 Dalgliesh Gilpin Paxton Architects

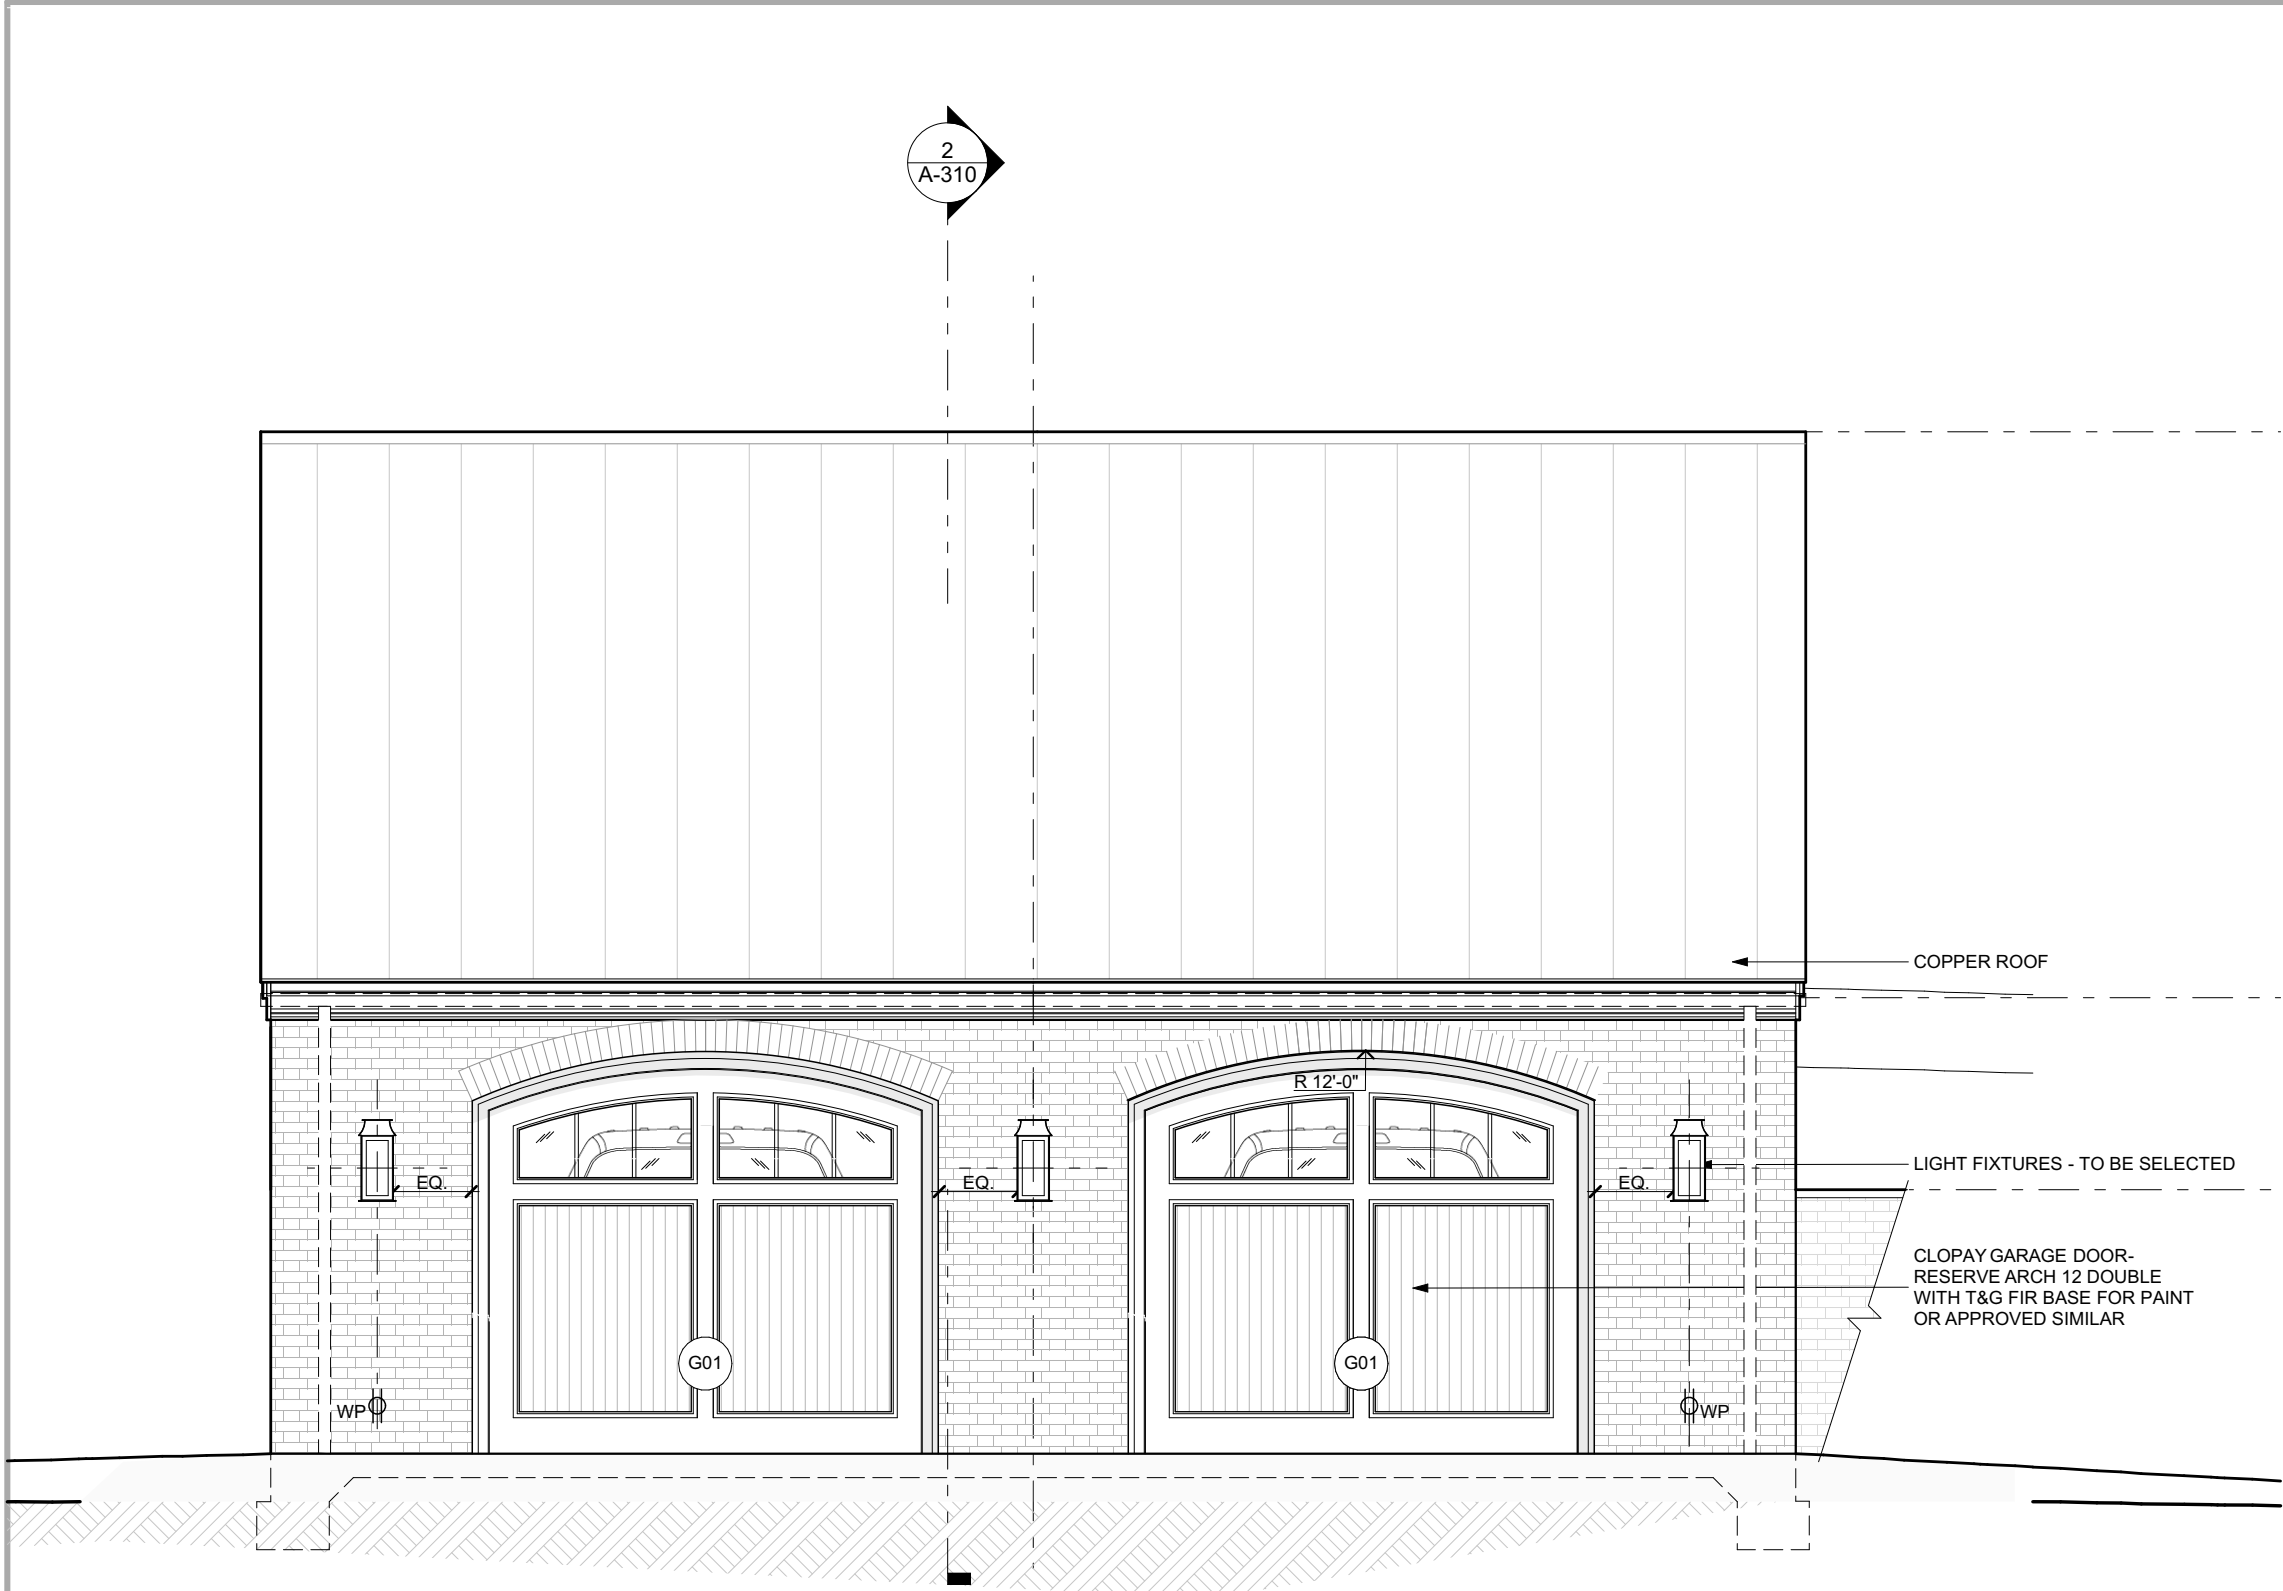


1 GARAGE DOOR ELEVATION
SCALE: 1/4" = 1'-0"

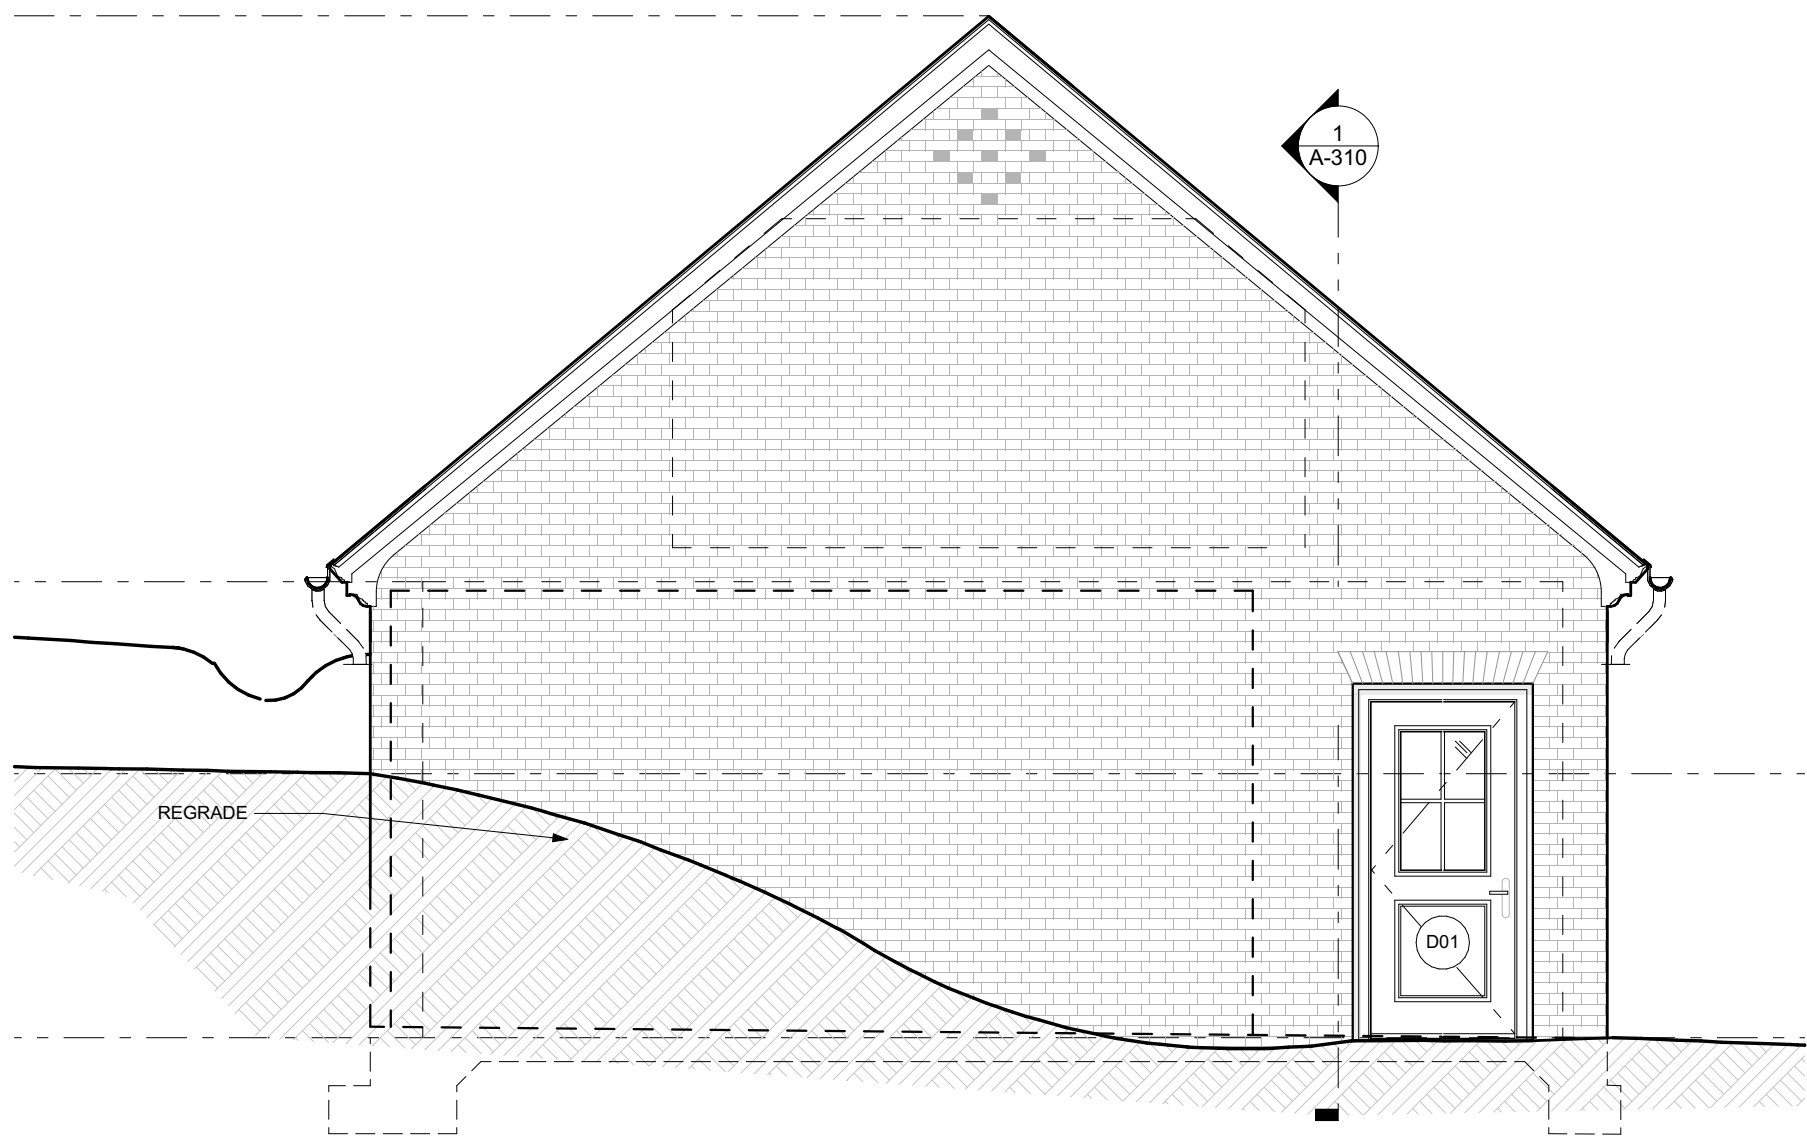


2 PEDESTRIAN DOOR ELEVATION
SCALE: 1/4" = 1'-0"

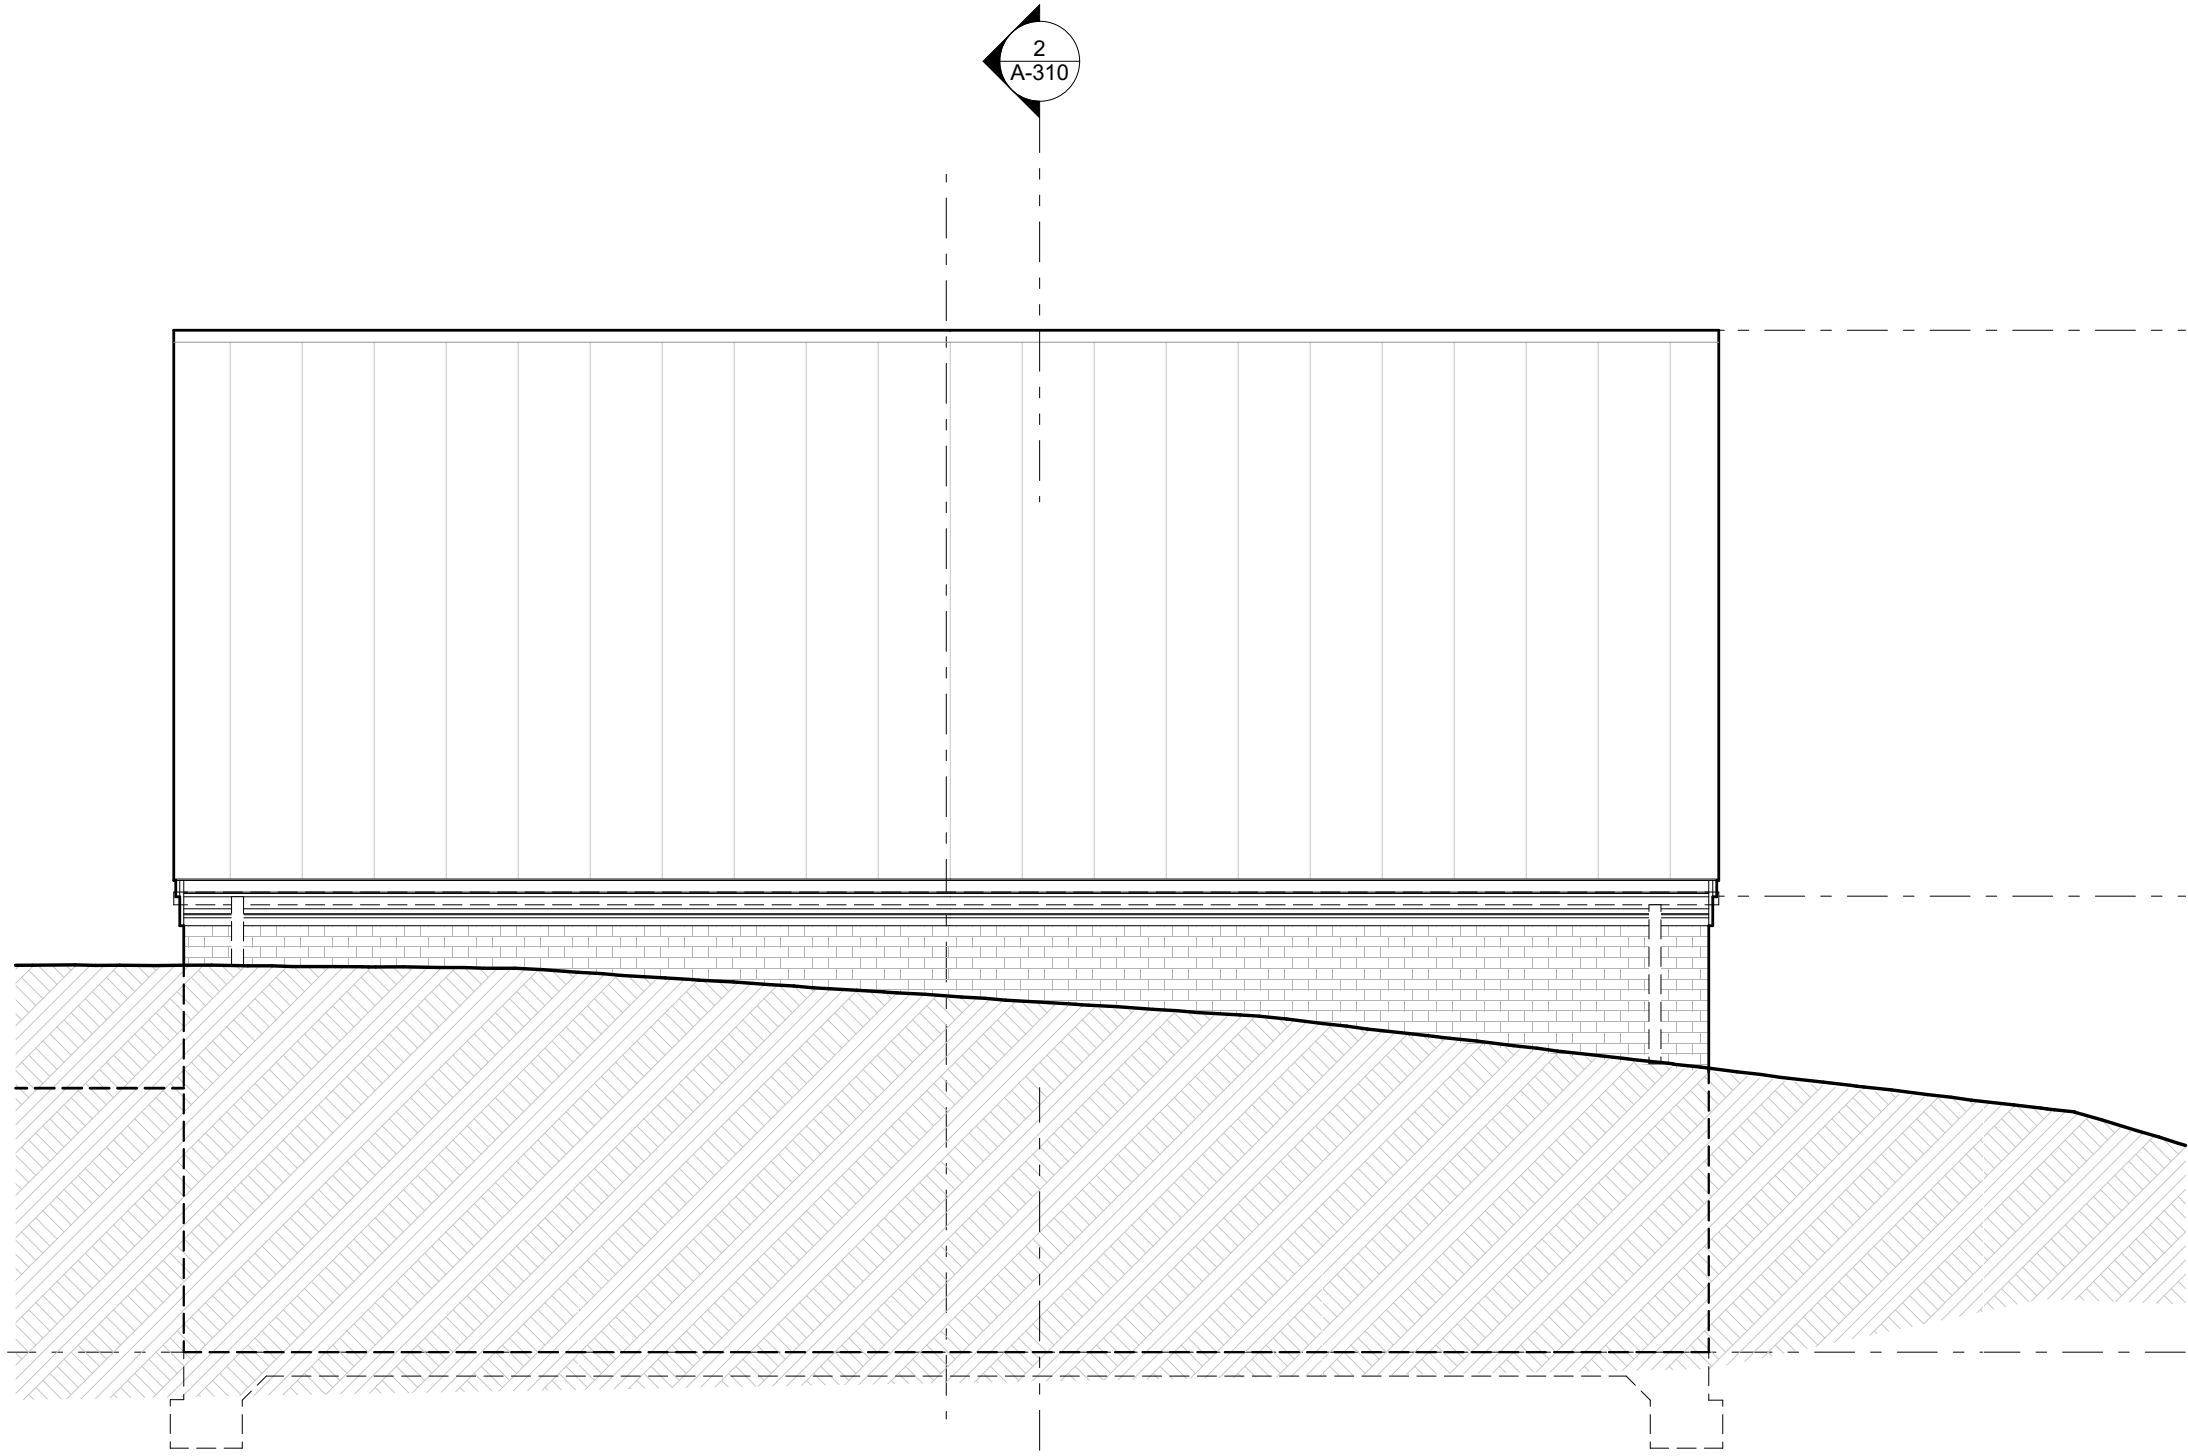

3 GARDEN ELEVATION
SCALE: 1/4" = 1'-0"

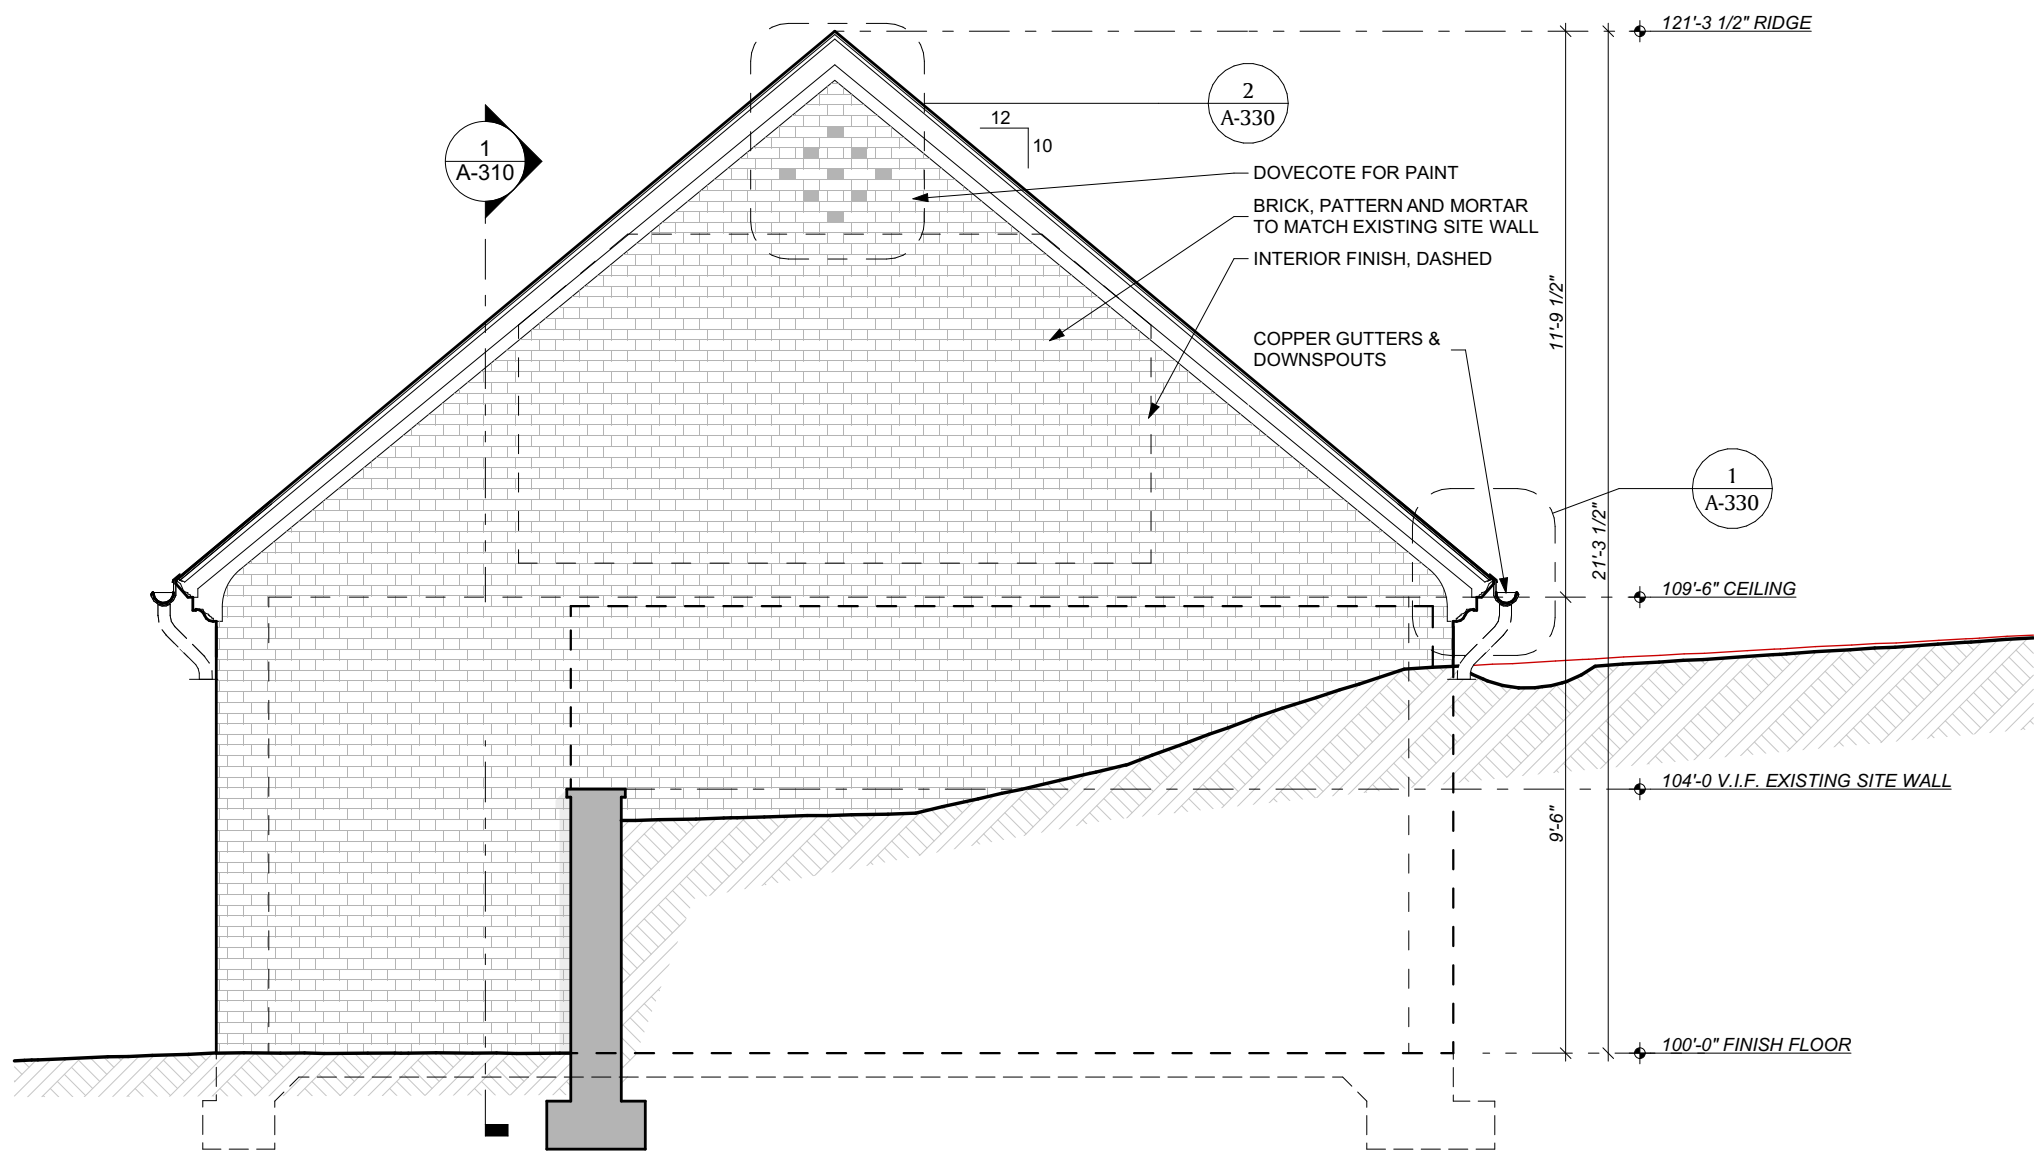

4 EXISTING SITE WALL ELEVATION
SCALE: 1/4" = 1'-0"

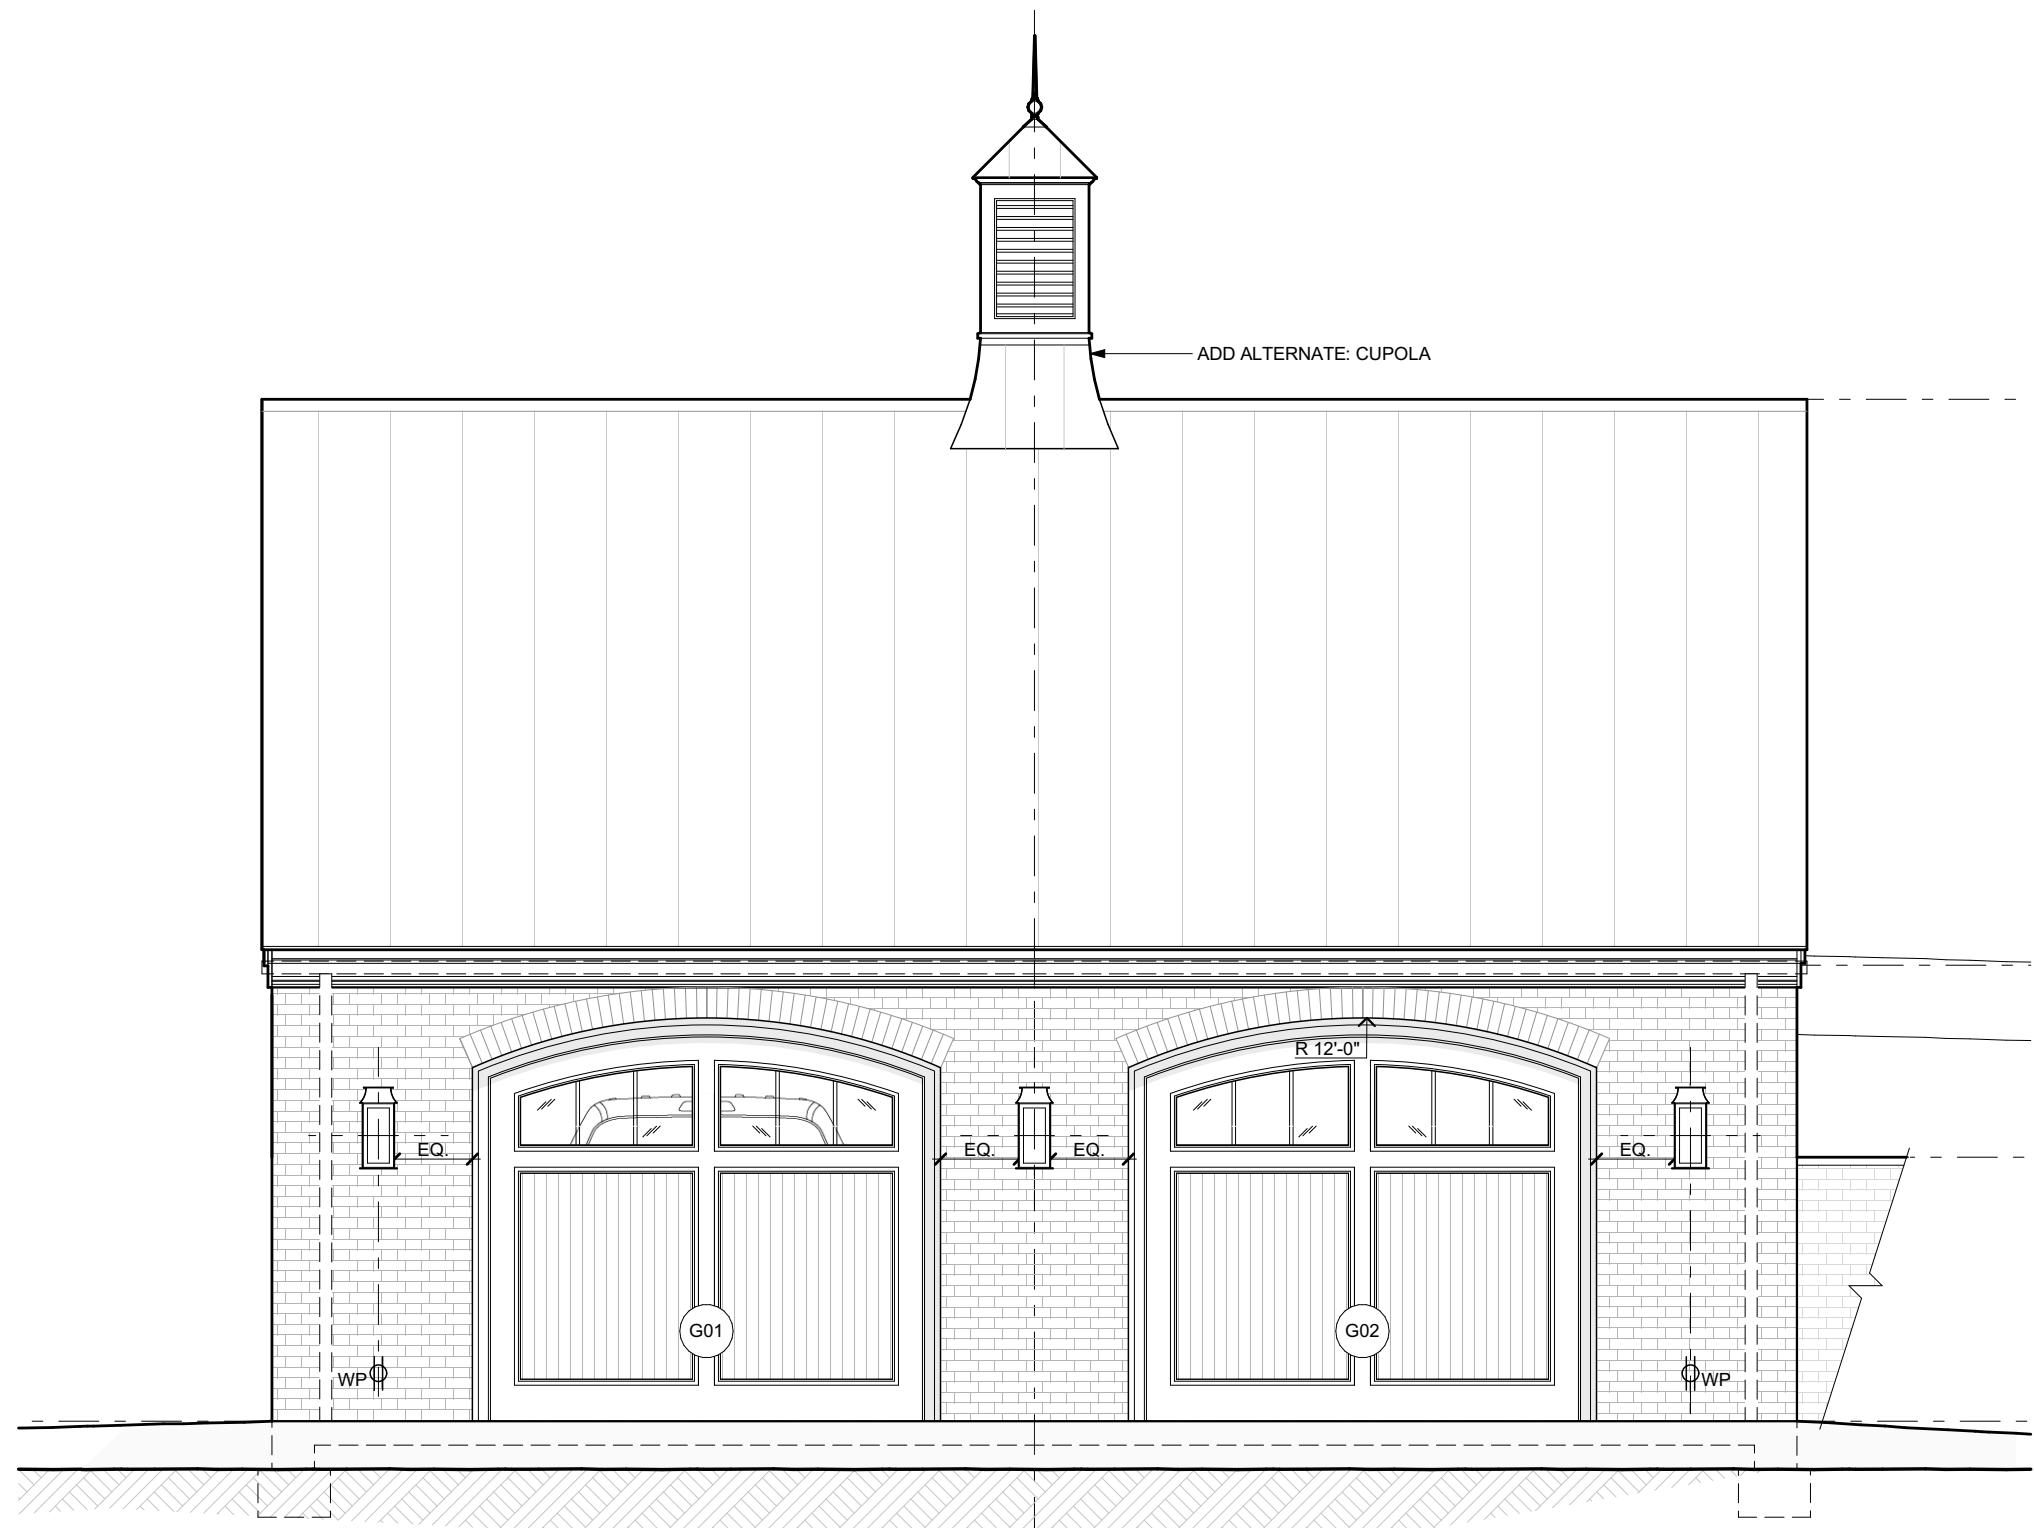

5 GARAGE DOOR ELEVATION - CUPOLA ALTERNATE
SCALE: 1/4" = 1'-0"

TIVOLI FARM - GARAGE - ELEVATIONS

KEY

TO BE DEMOLISHED

EXISTING TO REMAIN

NEW BUILDING CONSTRUCTION

GENERAL

1. FURNITURE AND GRAYSCALE ITEMS ARE NOT IN CONTRACT (NIC); PROVIDED BY OWNER

2. ALL EXTERIOR DIMENSIONS SHOWN FROM FACE OF SHEATHING OR MASONRY, UNO

3. ALL INTERIOR DIMENSIONS SHOWN FROM FACE OF FINISH, UNO

GENERAL NOTES

01

02

03


Revisions	
Release	Date
01	1/13/2023
02	2/6/2023

Job #	Date
4504.1	06 FEB 2023
Drawn	Checked
DRG	EWA


CONTRACTOR TO VERIFY ALL DIMENSIONS AT SITE AND SHALL NOTIFY ARCHITECT OF ANY DISCREPANCIES BEFORE PROCEEDING

© 2021 Dalgliesh Gilpin Paxton Architects

PRINTED 2/6/2023, 4:49 PM

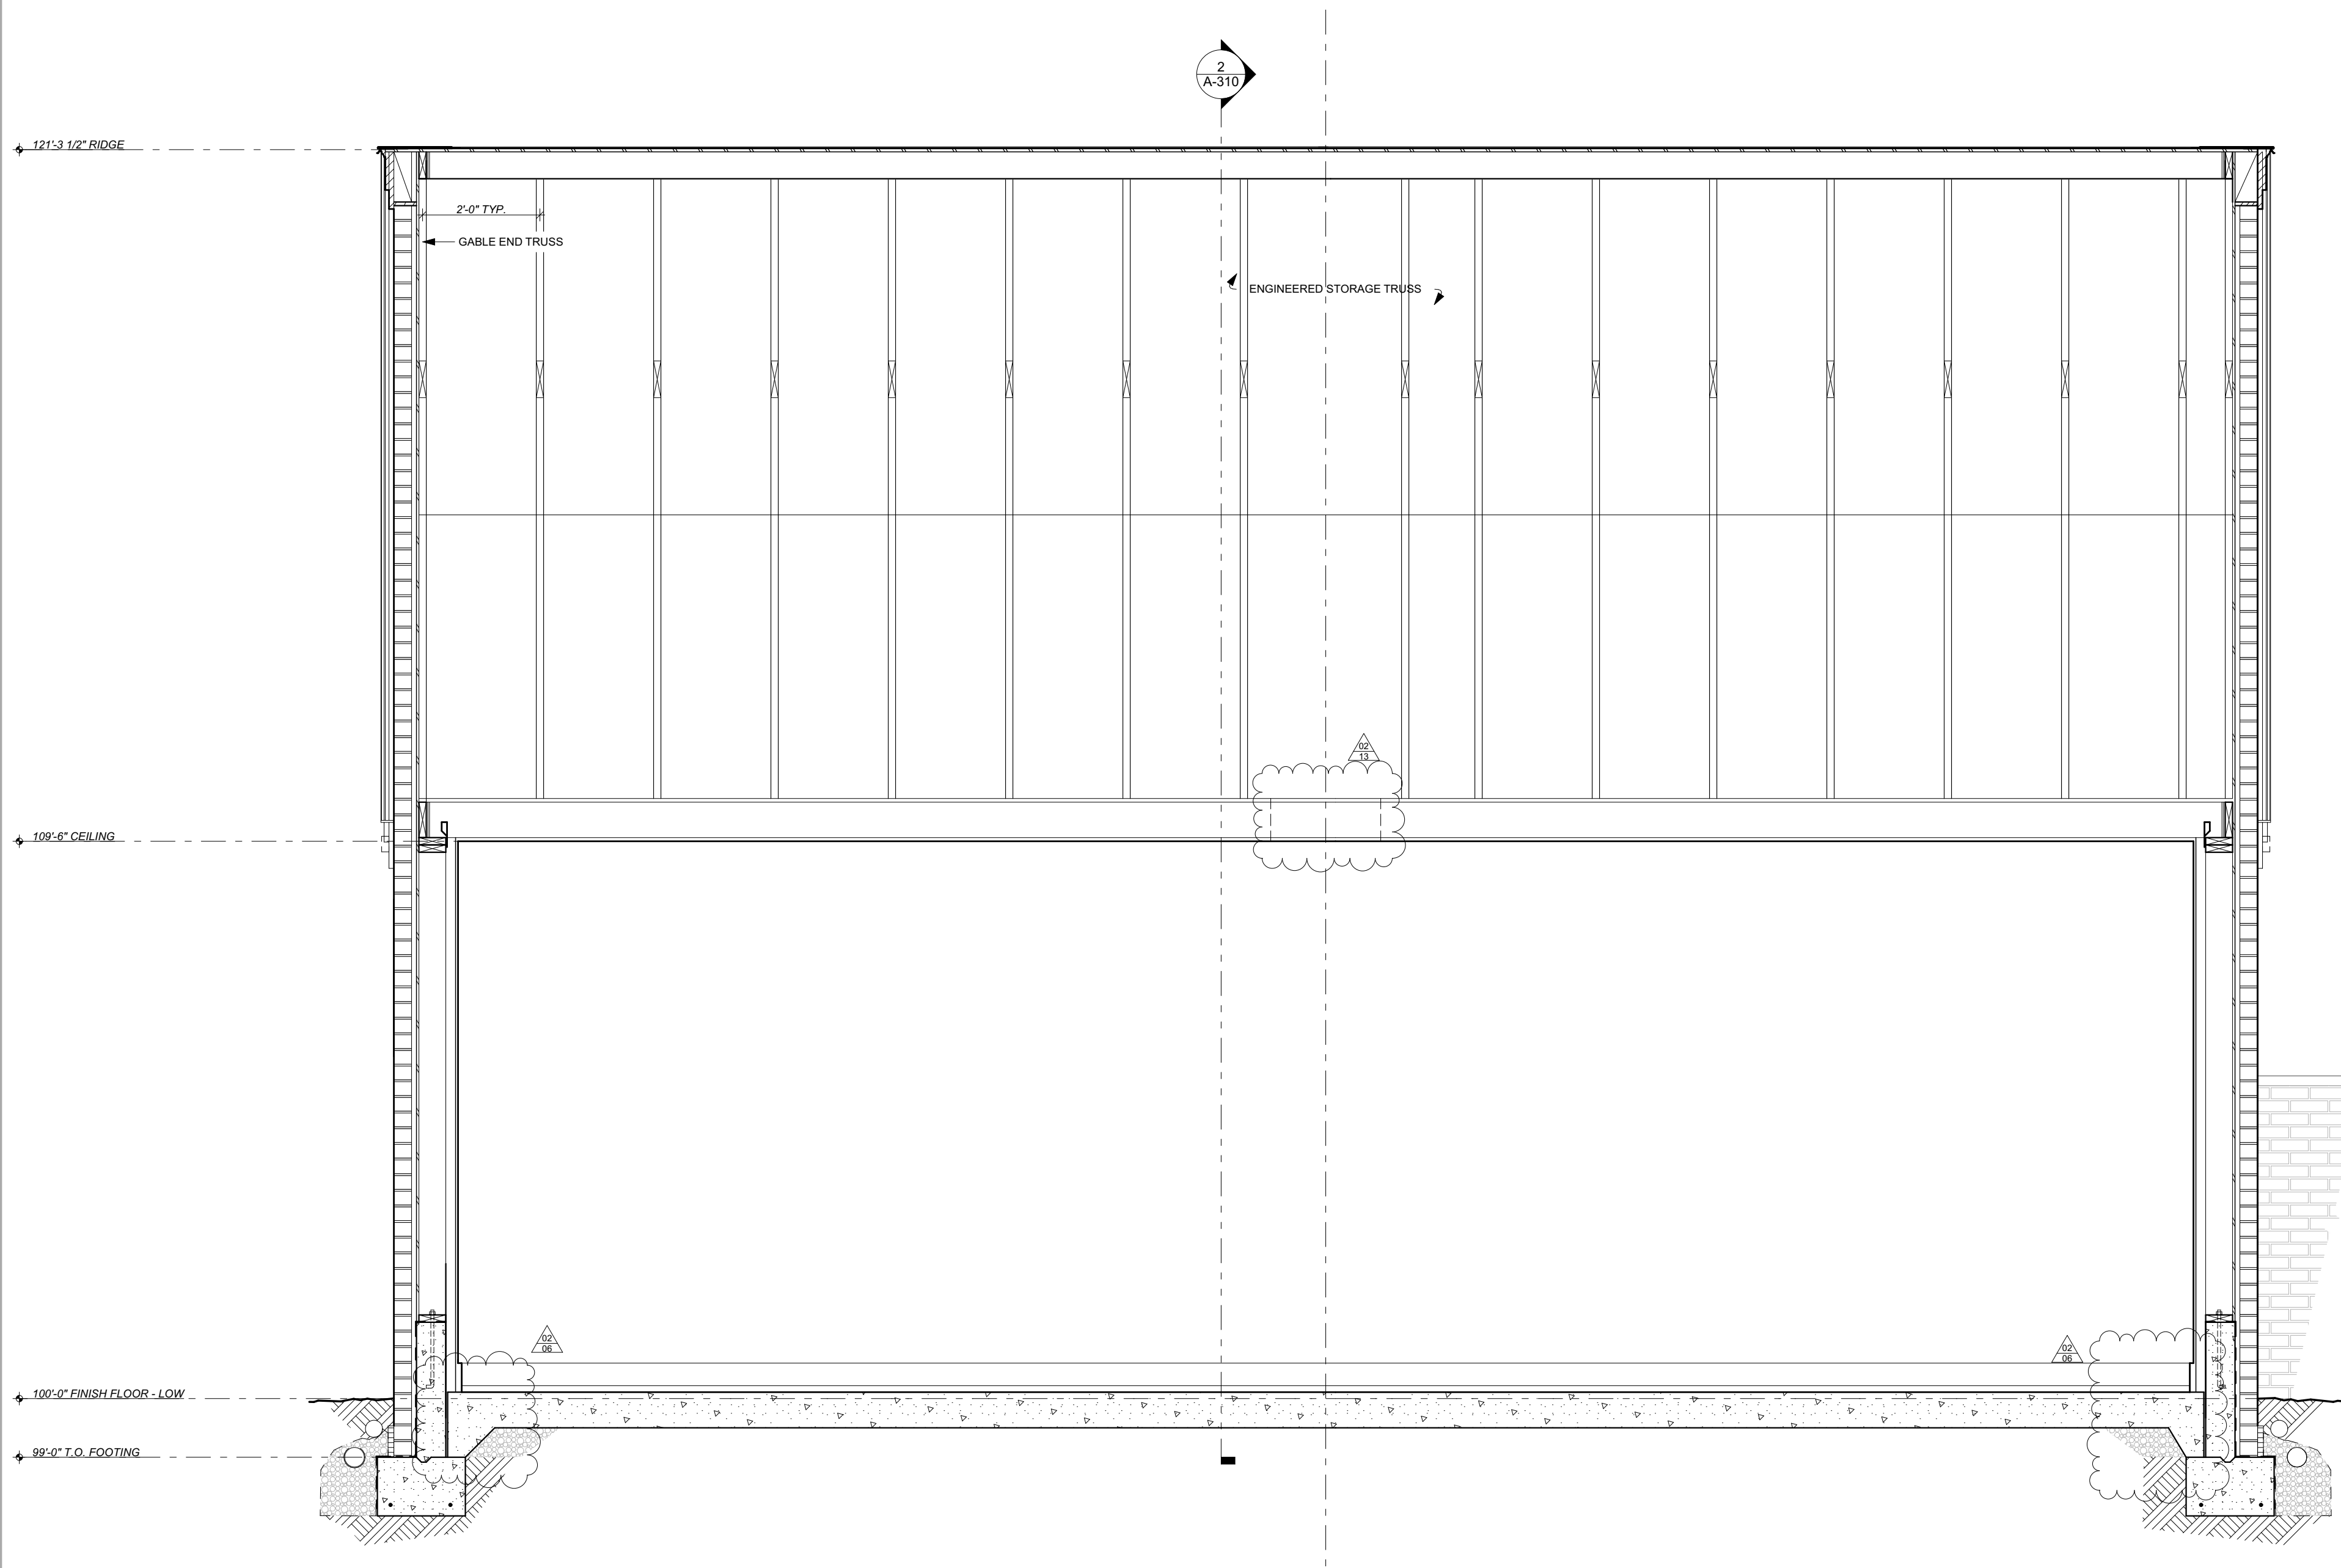

1 LONGITUDINAL BUILDING SECTION
SCALE: 1/2" = 1'-0"

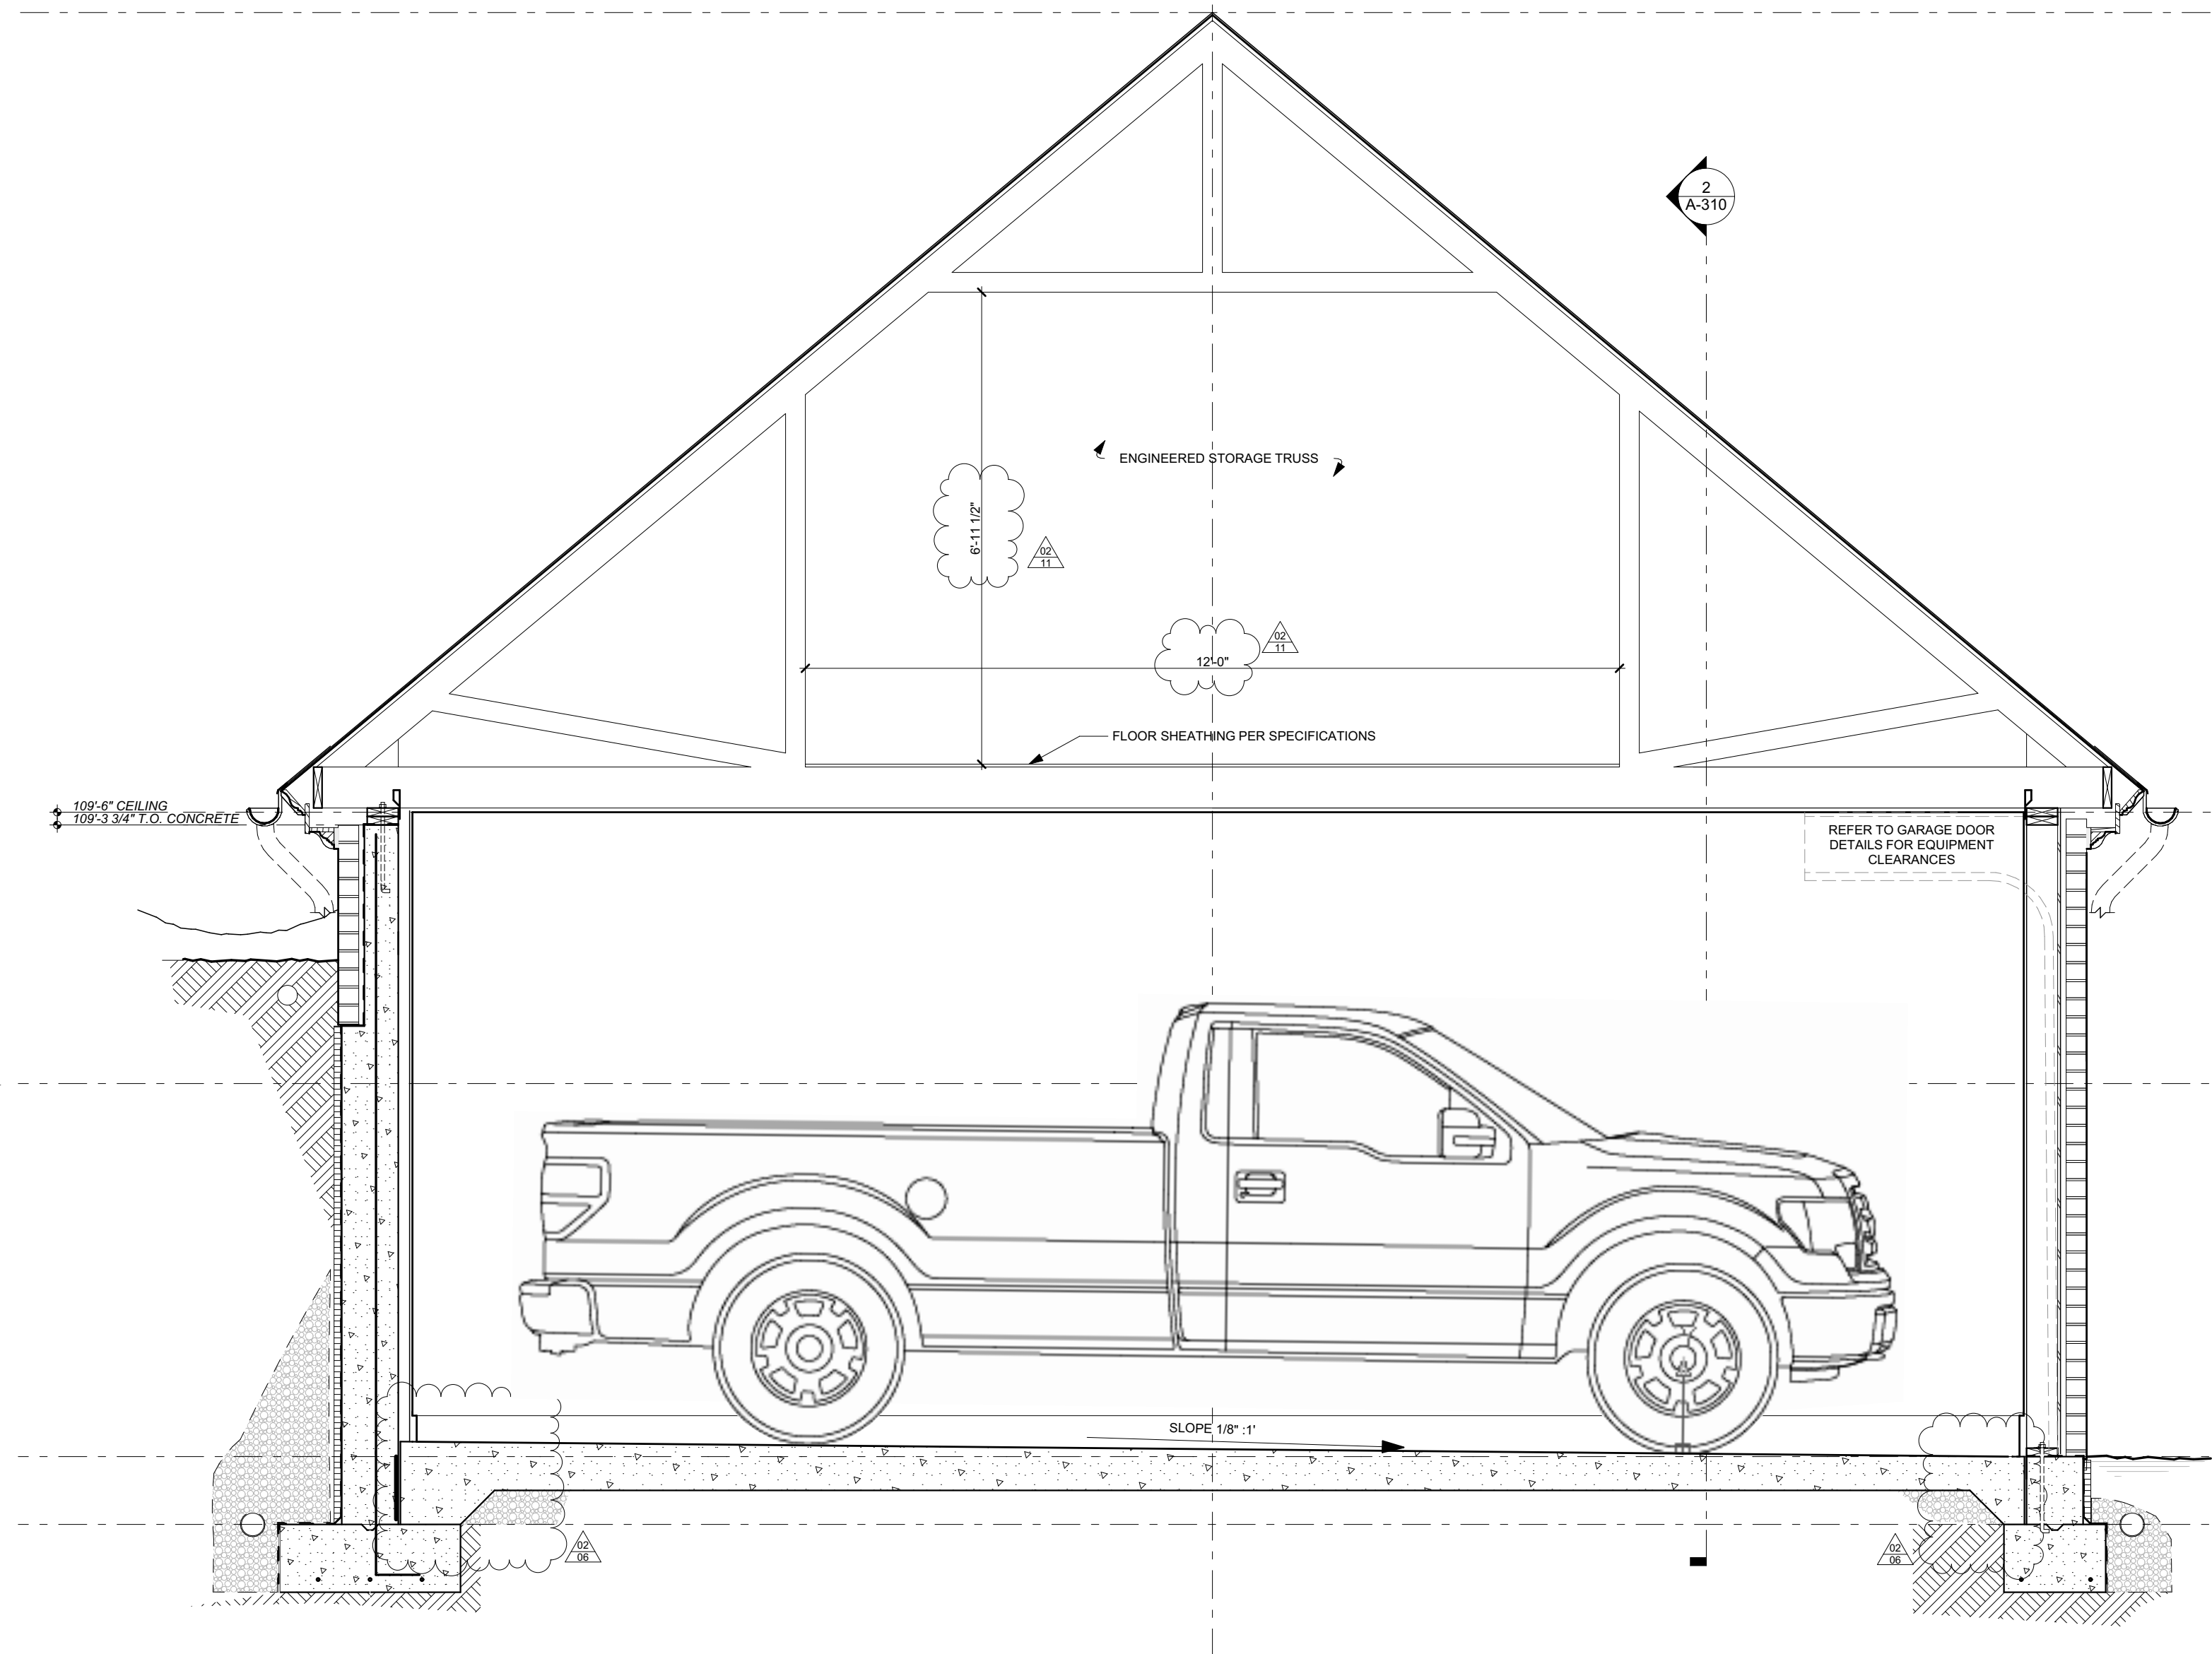

2 LATITUDINAL BUILDING SECTION
SCALE: 1/2" = 1'-0"

DALGLIESH
GILPIN
PAXTON

ARCHITECTS

Approved:

Tivoli Farm - Garage
9171 Tivoli Drive
Gordonsville, VA

BUILDING SECTIONS
CONSTRUCTION DOCUMENTS

Revisions

Release	Date
01	1/19/2023
02	2/6/2023





Job #	Date
4504.1	06 FEB 2023
Drawn	Checked
DRG	EWA

CONTRACTOR TO VERIFY ALL
DIMENSIONS AT SITE AND SHALL
NOTIFY ARCHITECT OF ANY
DISCREPANCIES BEFORE
PROCEEDING

© 2021 Dalgliesh Gilpin Paxton Architects

A-310

PRINTED 2/6/2023, 4:49 PM

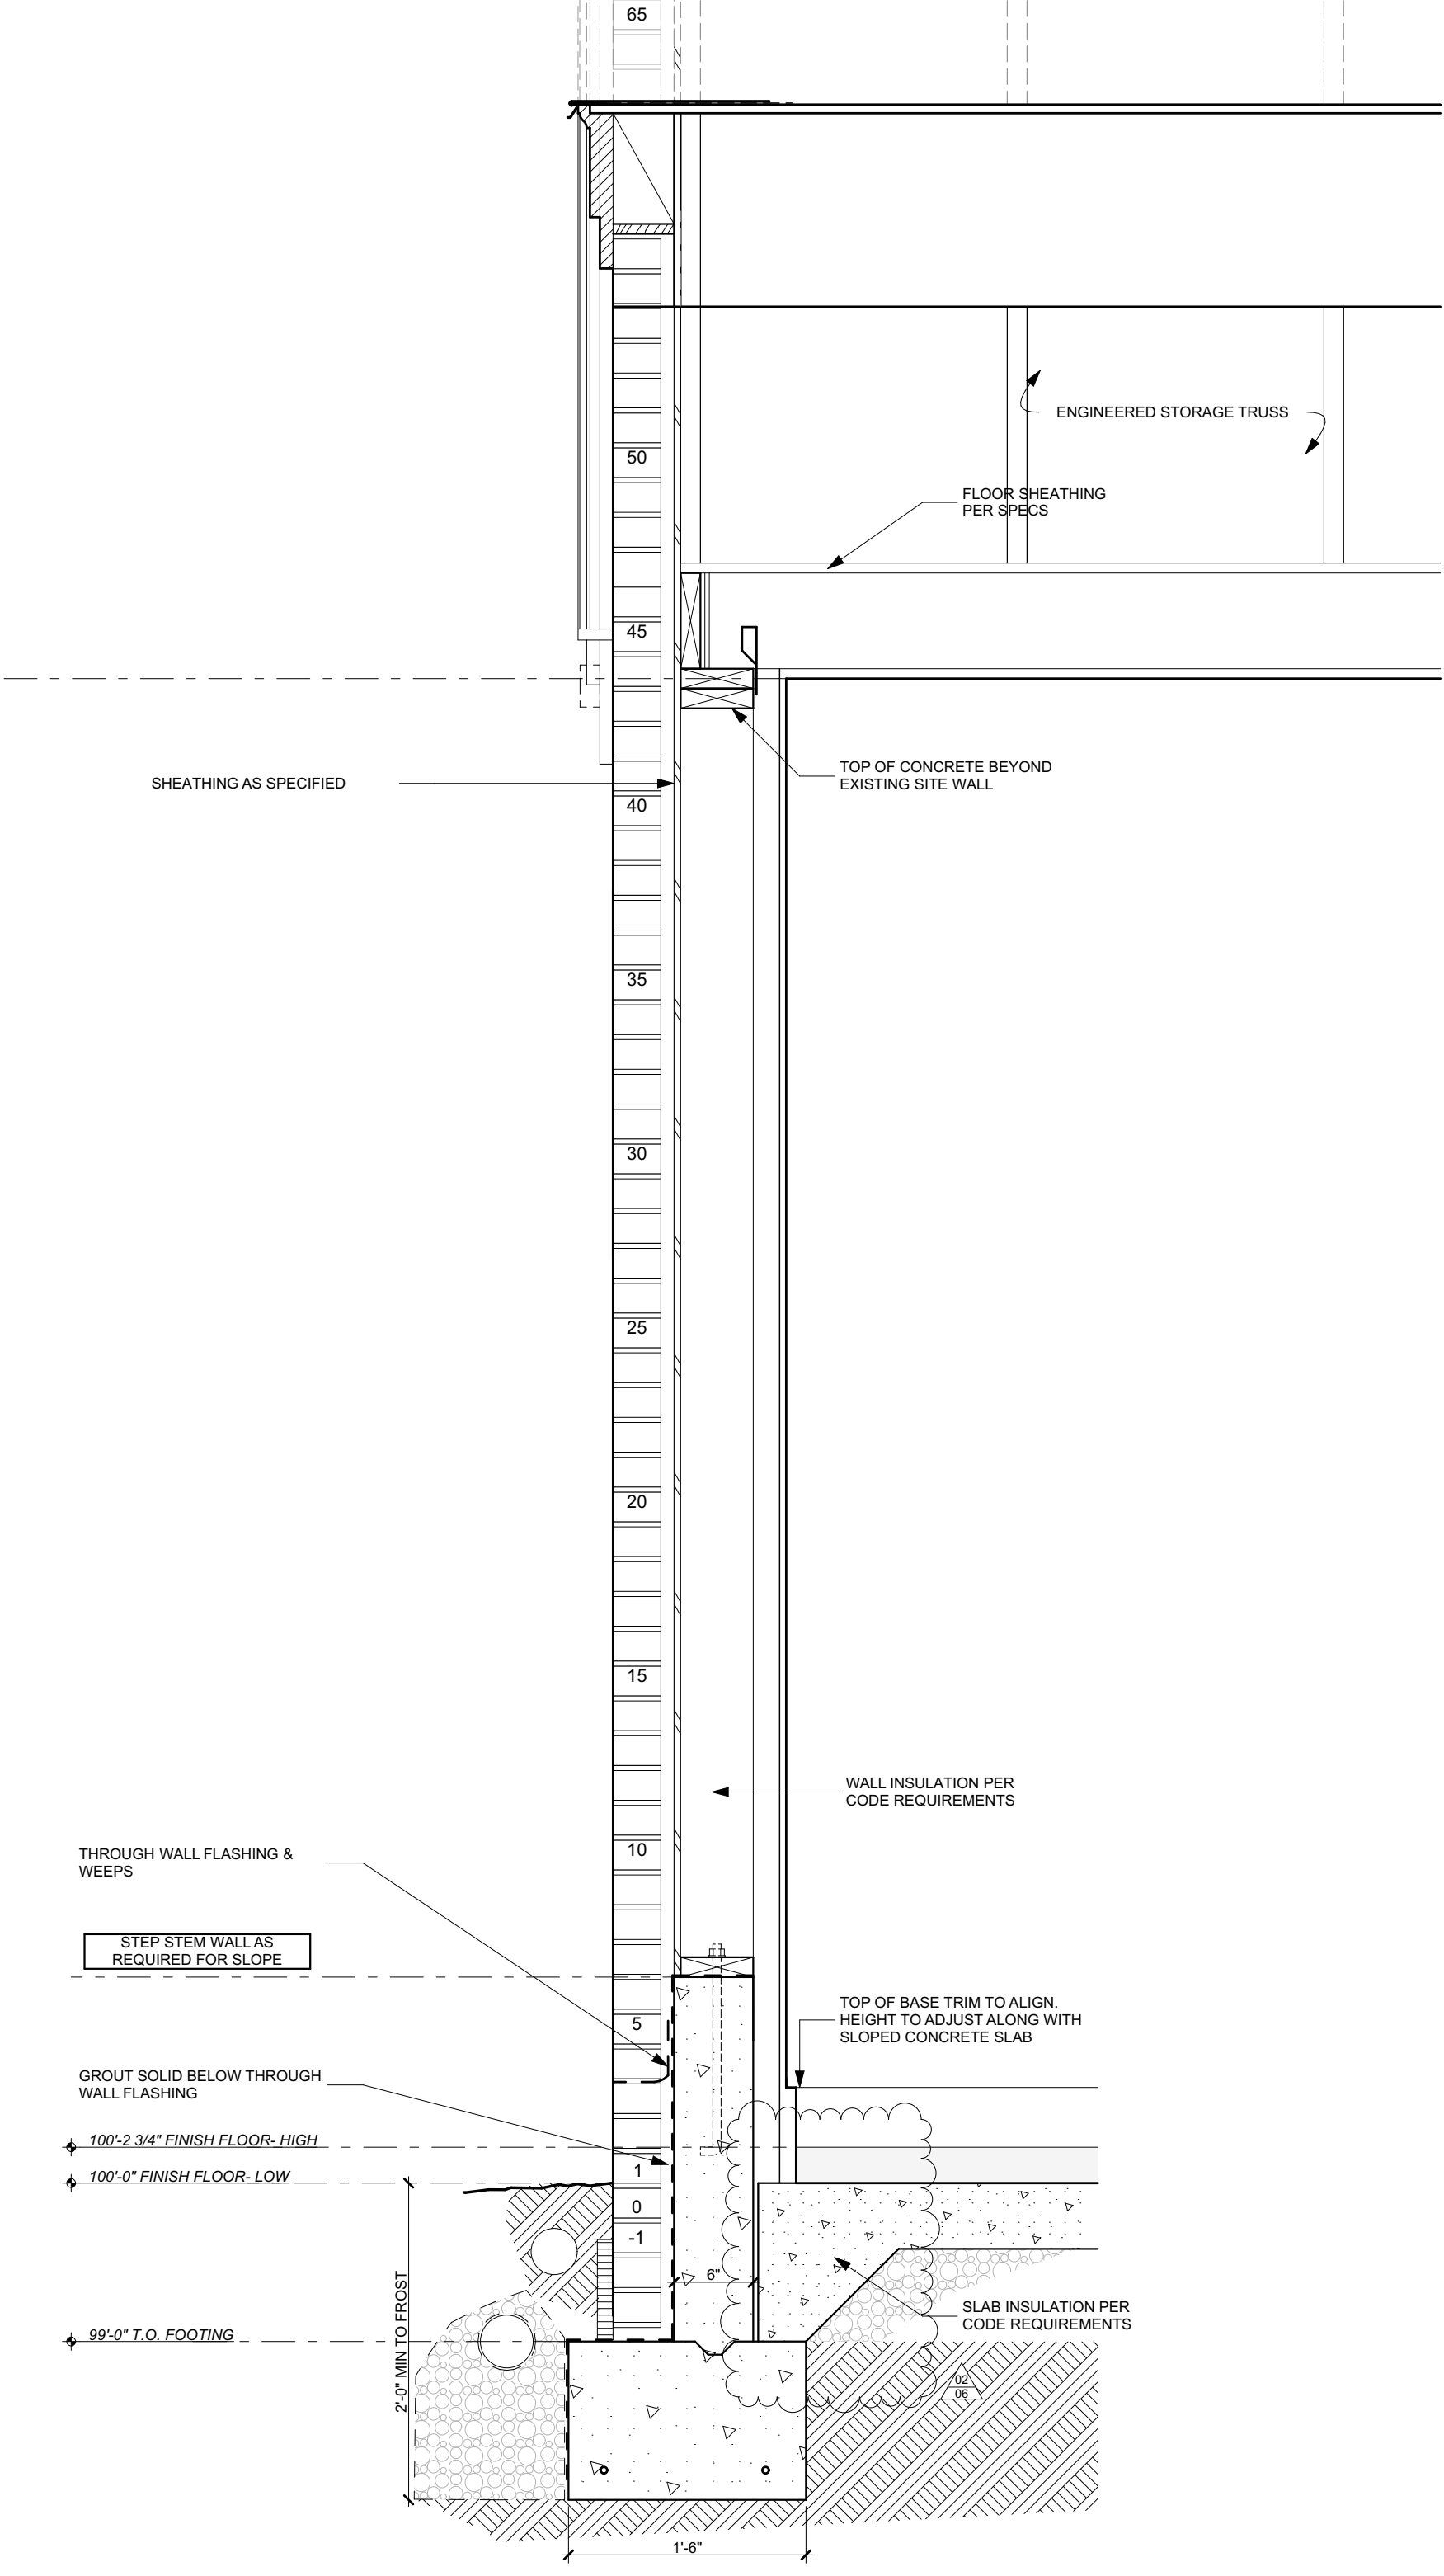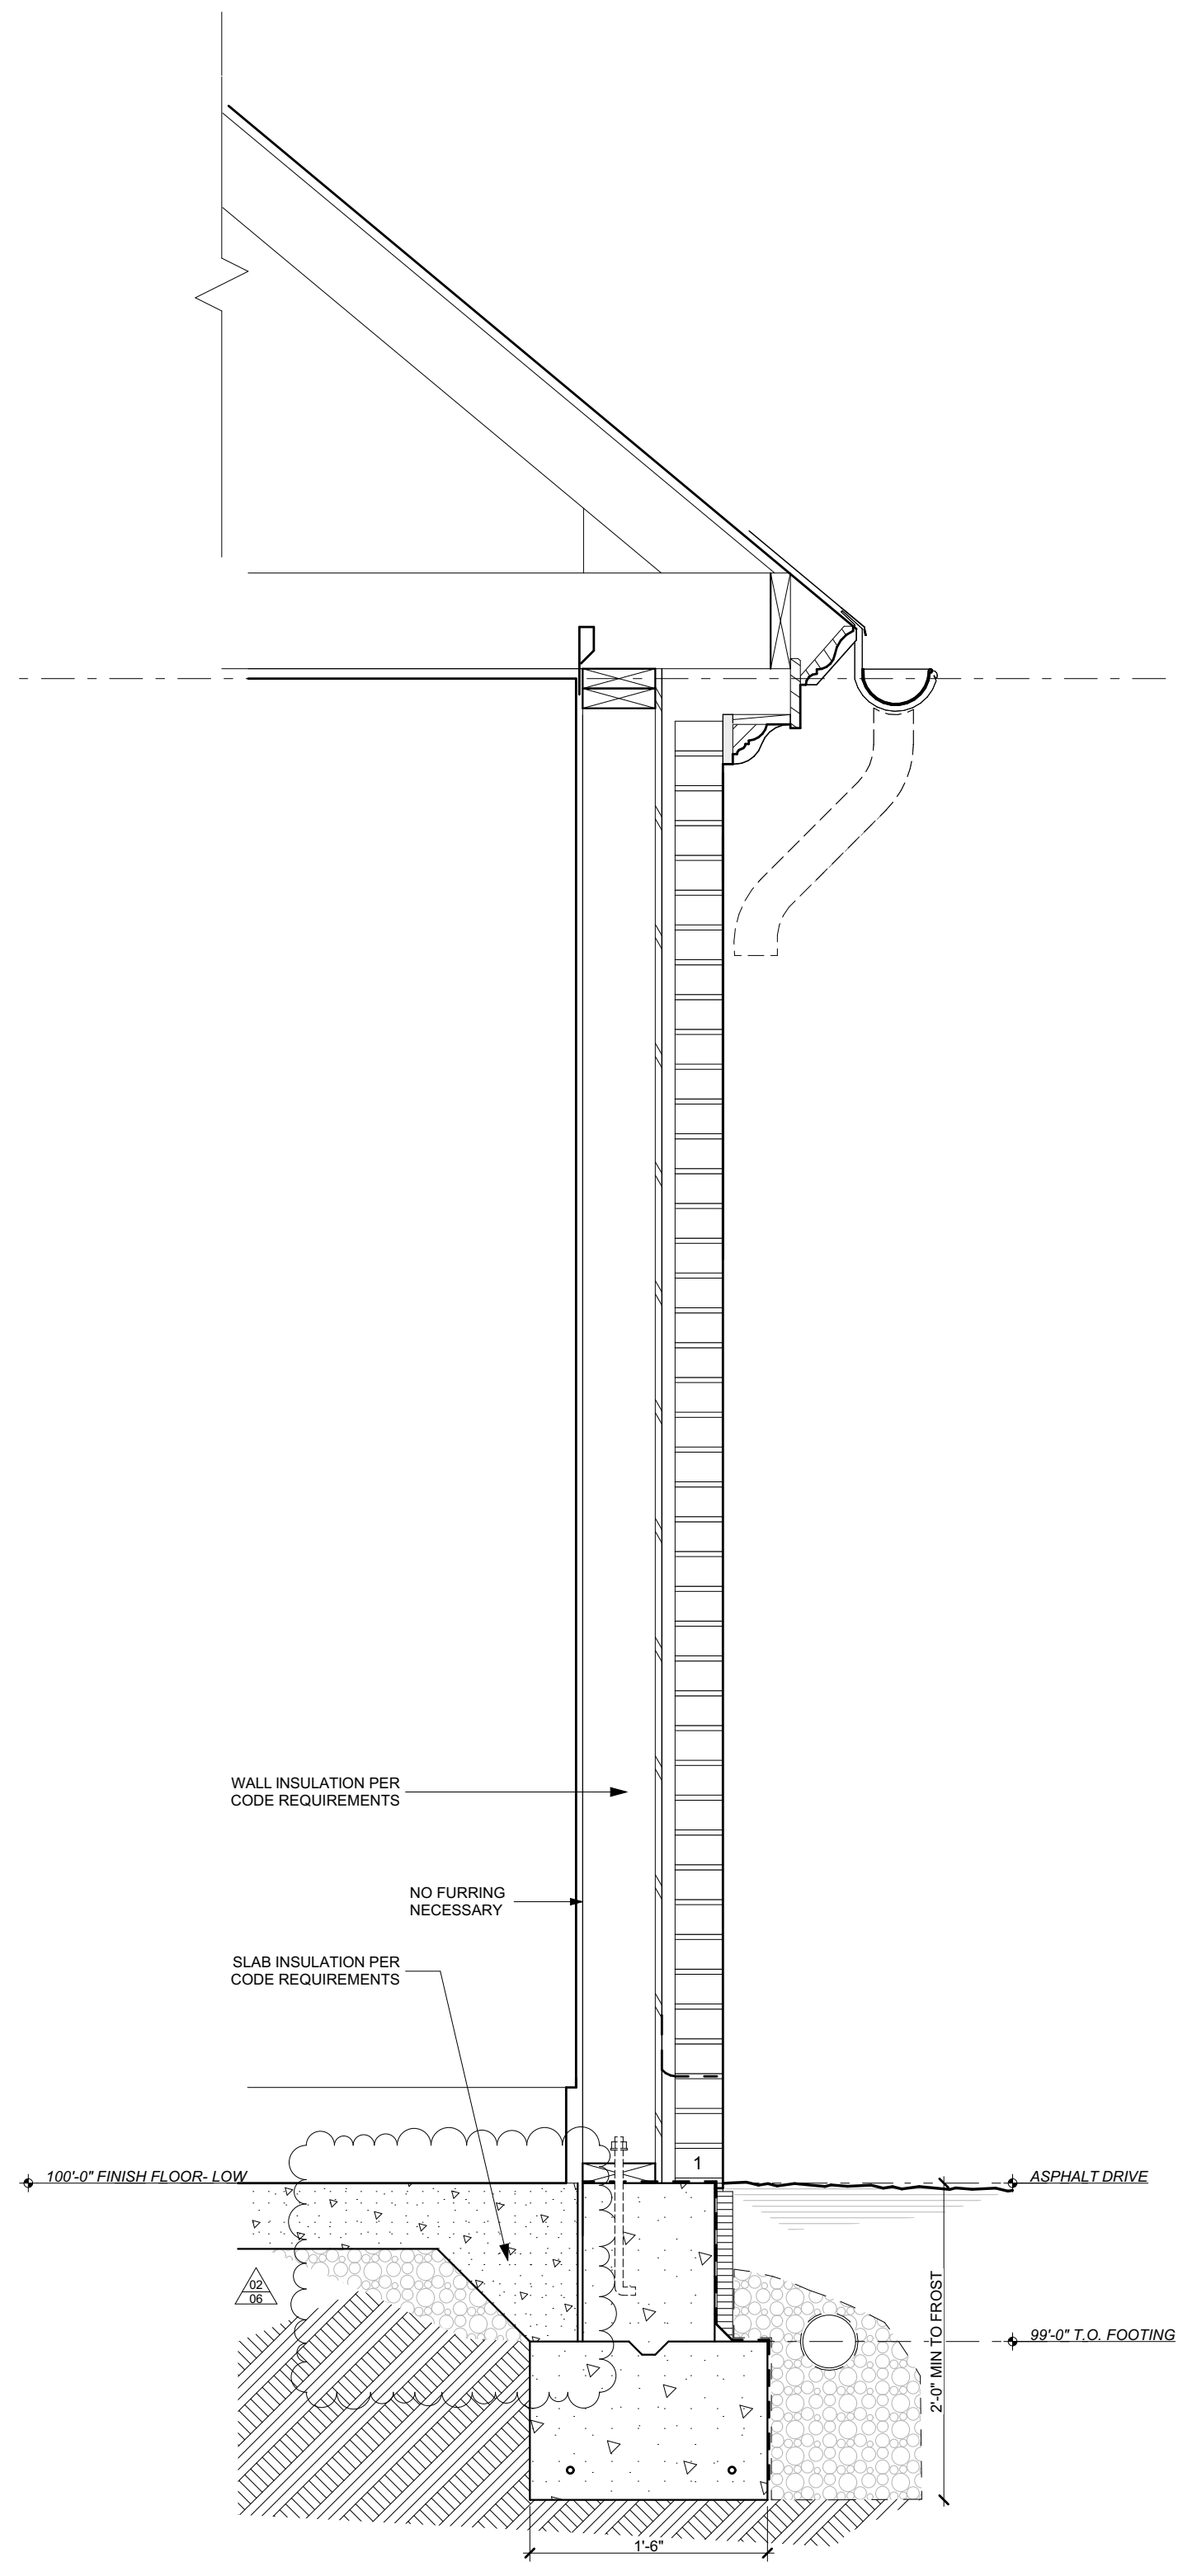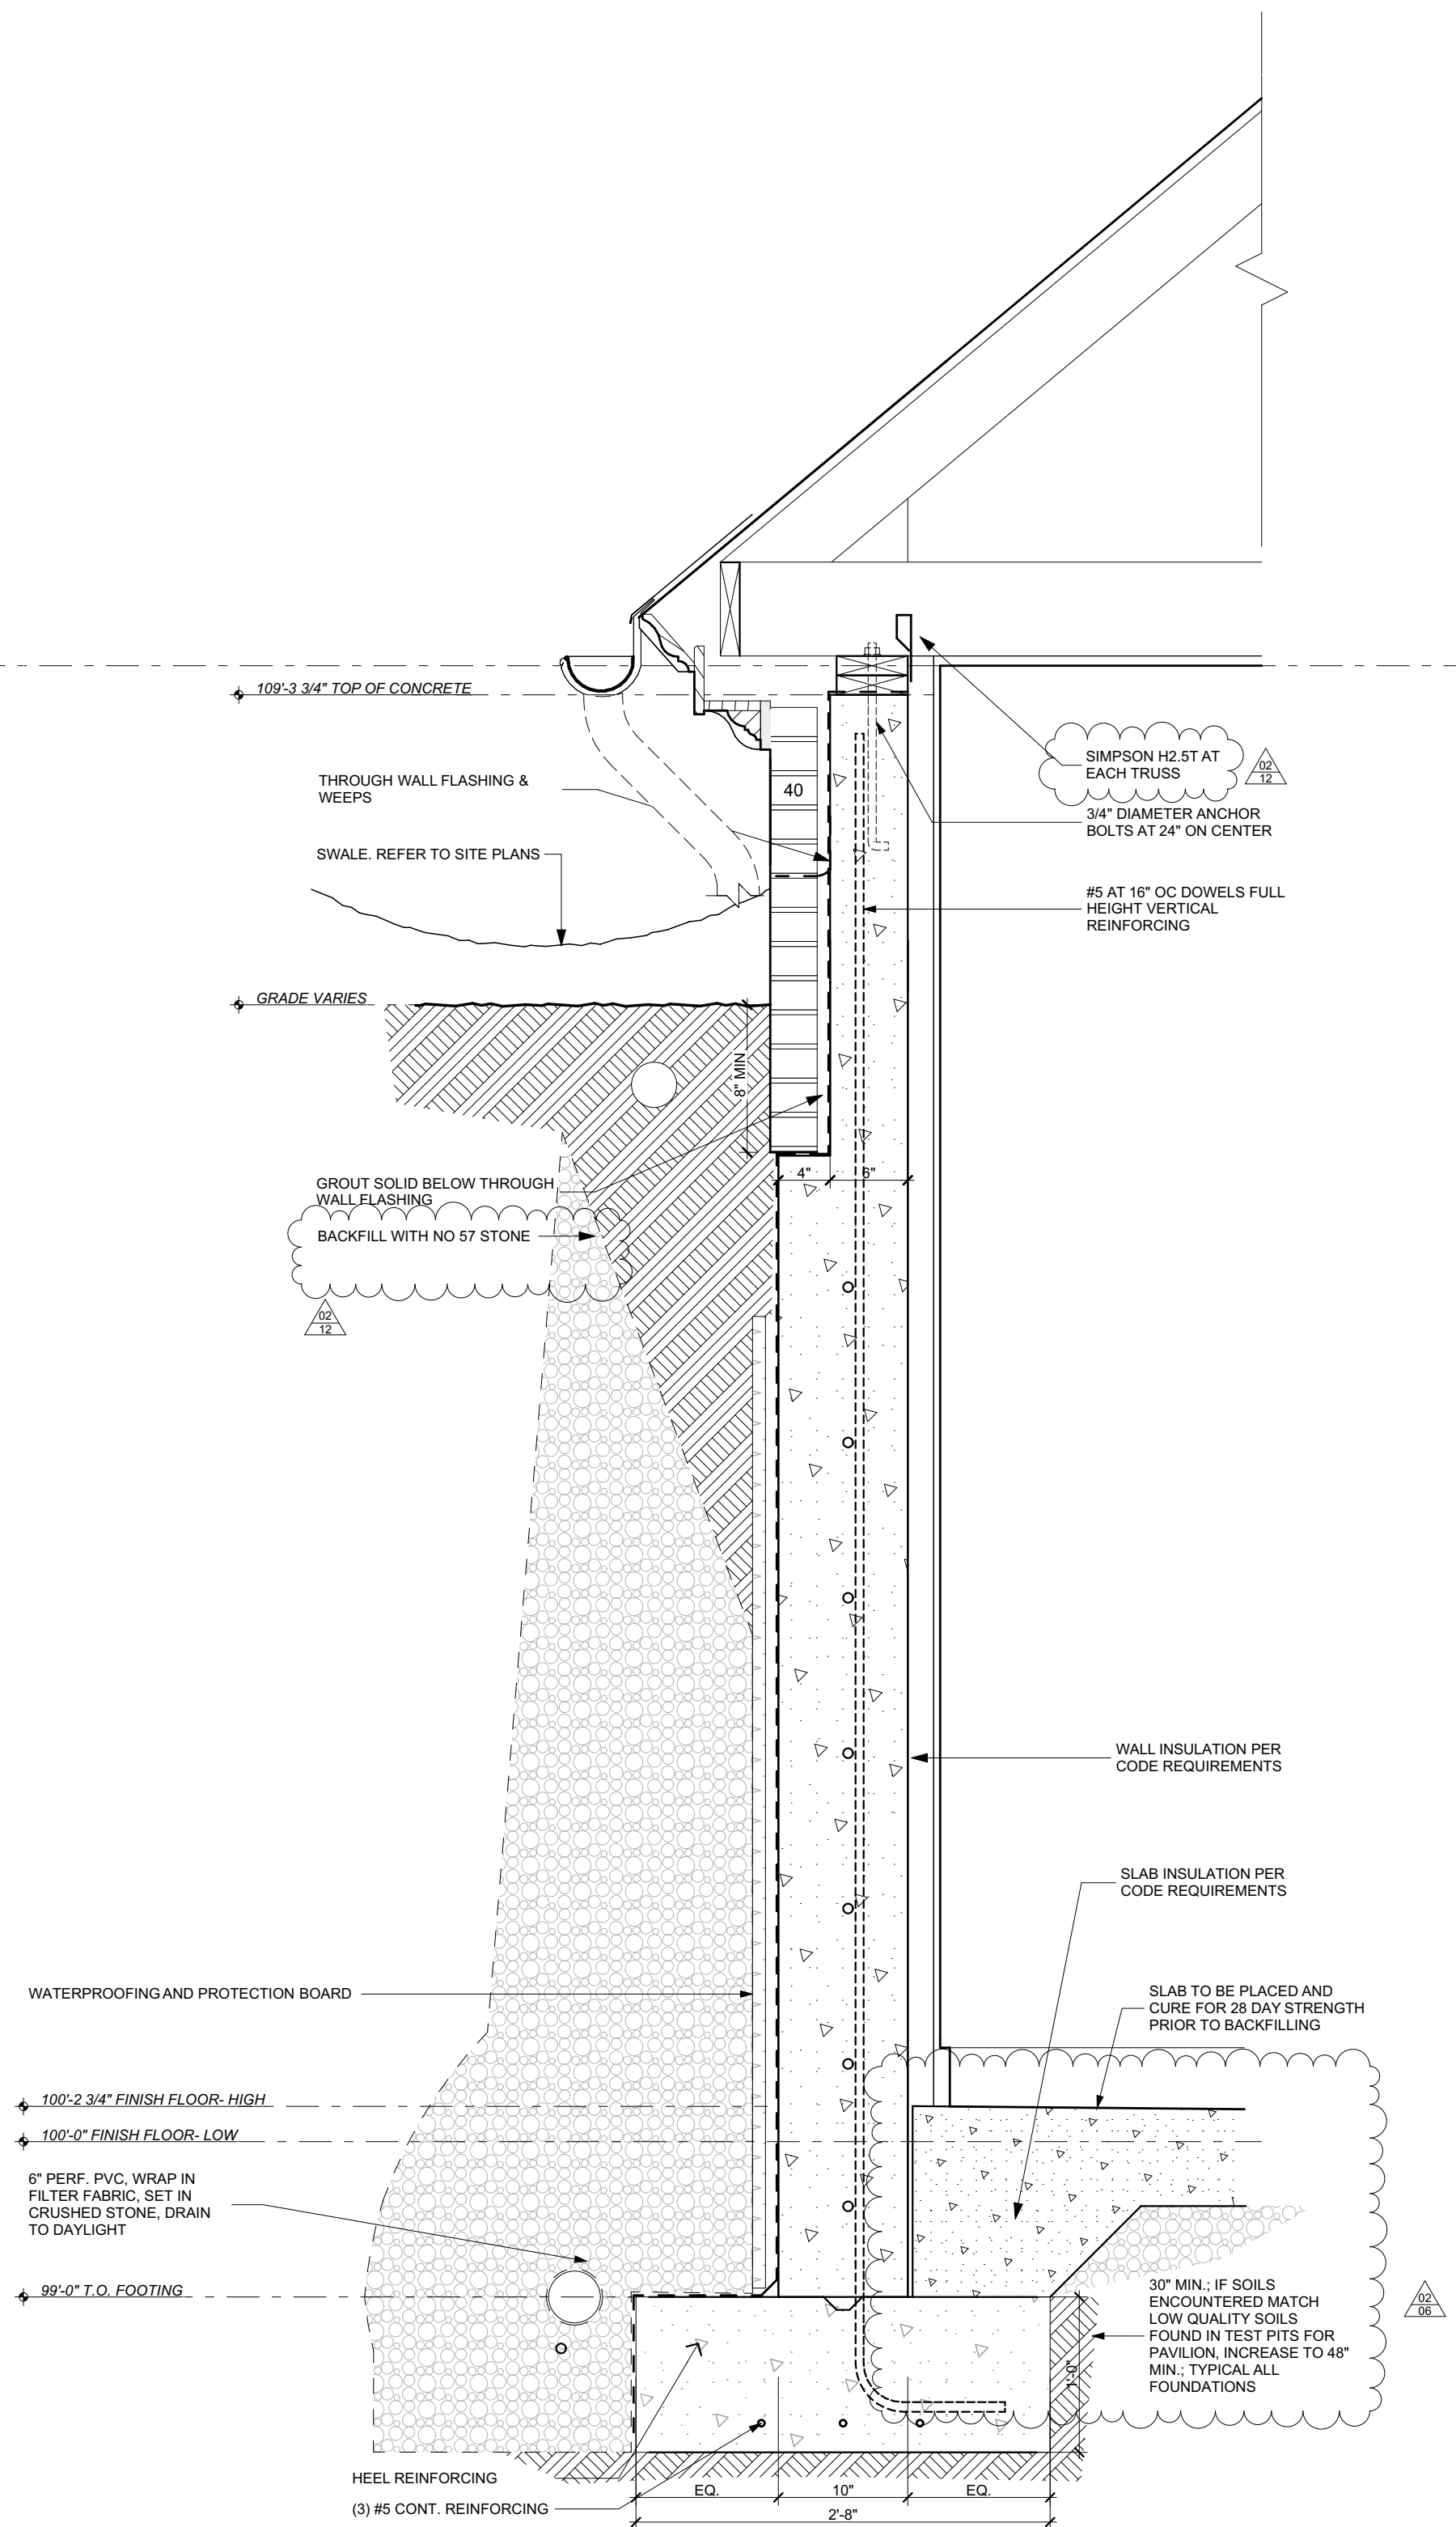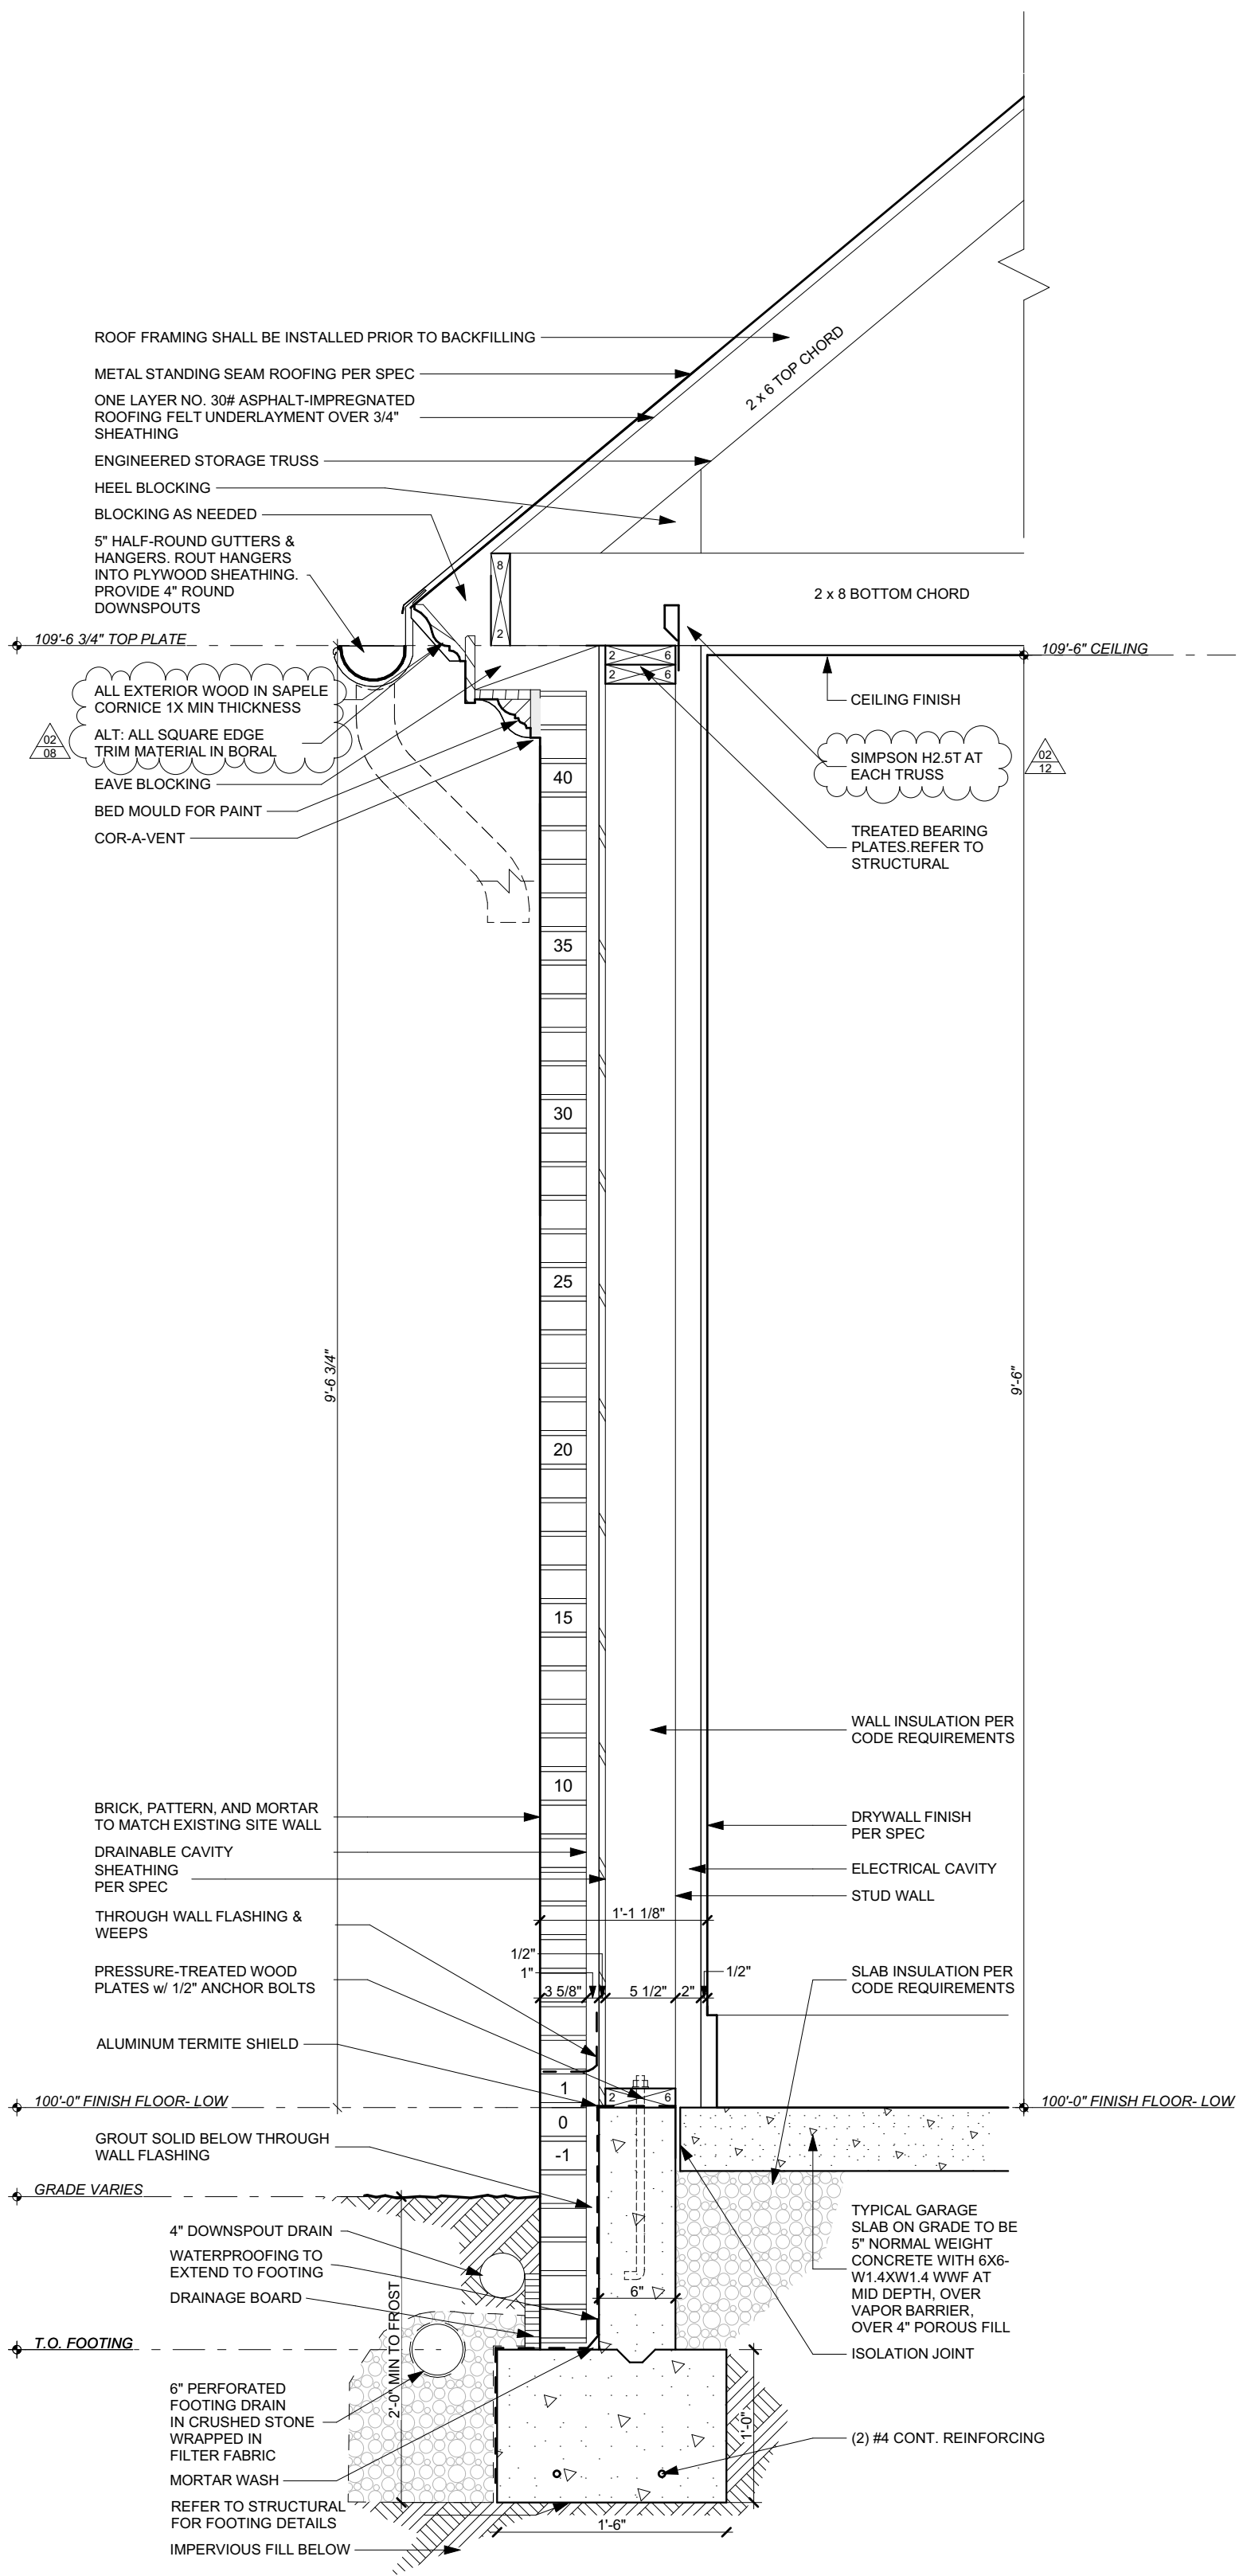

DALGLIESH
GILPIN
PAXTON

ARCHITECTS

Approved:

Tivoli Farm - Garage
9171 Tivoli Drive
Gordonsville, VA

WALL SECTIONS
CONSTRUCTION DOCUMENTS

Revisions

Release	Date
01	1/15/2023
02	2/6/2023

Job #	Date
4504.1	06 FEB 2023
Drawn	Checked
DRG	EWA

CONTRACTOR TO VERIFY ALL DIMENSIONS AT SITE AND SHALL NOTIFY ARCHITECT OF ANY DISCREPANCIES BEFORE PROCEEDING

© 2021 Dalgliesh Gilpin Paxton Architects


A-320

Revisions


[illegible]

Job #	Date
4504.1	06 FEB 2023
Drawn	Checked
DRG	EWA


CONTRACTOR TO VERIFY ALL
DIMENSIONS AT SITE AND SHALL
NOTIFY ARCHITECT OF ANY
DISCREPANCIES BEFORE
PROCEEDING

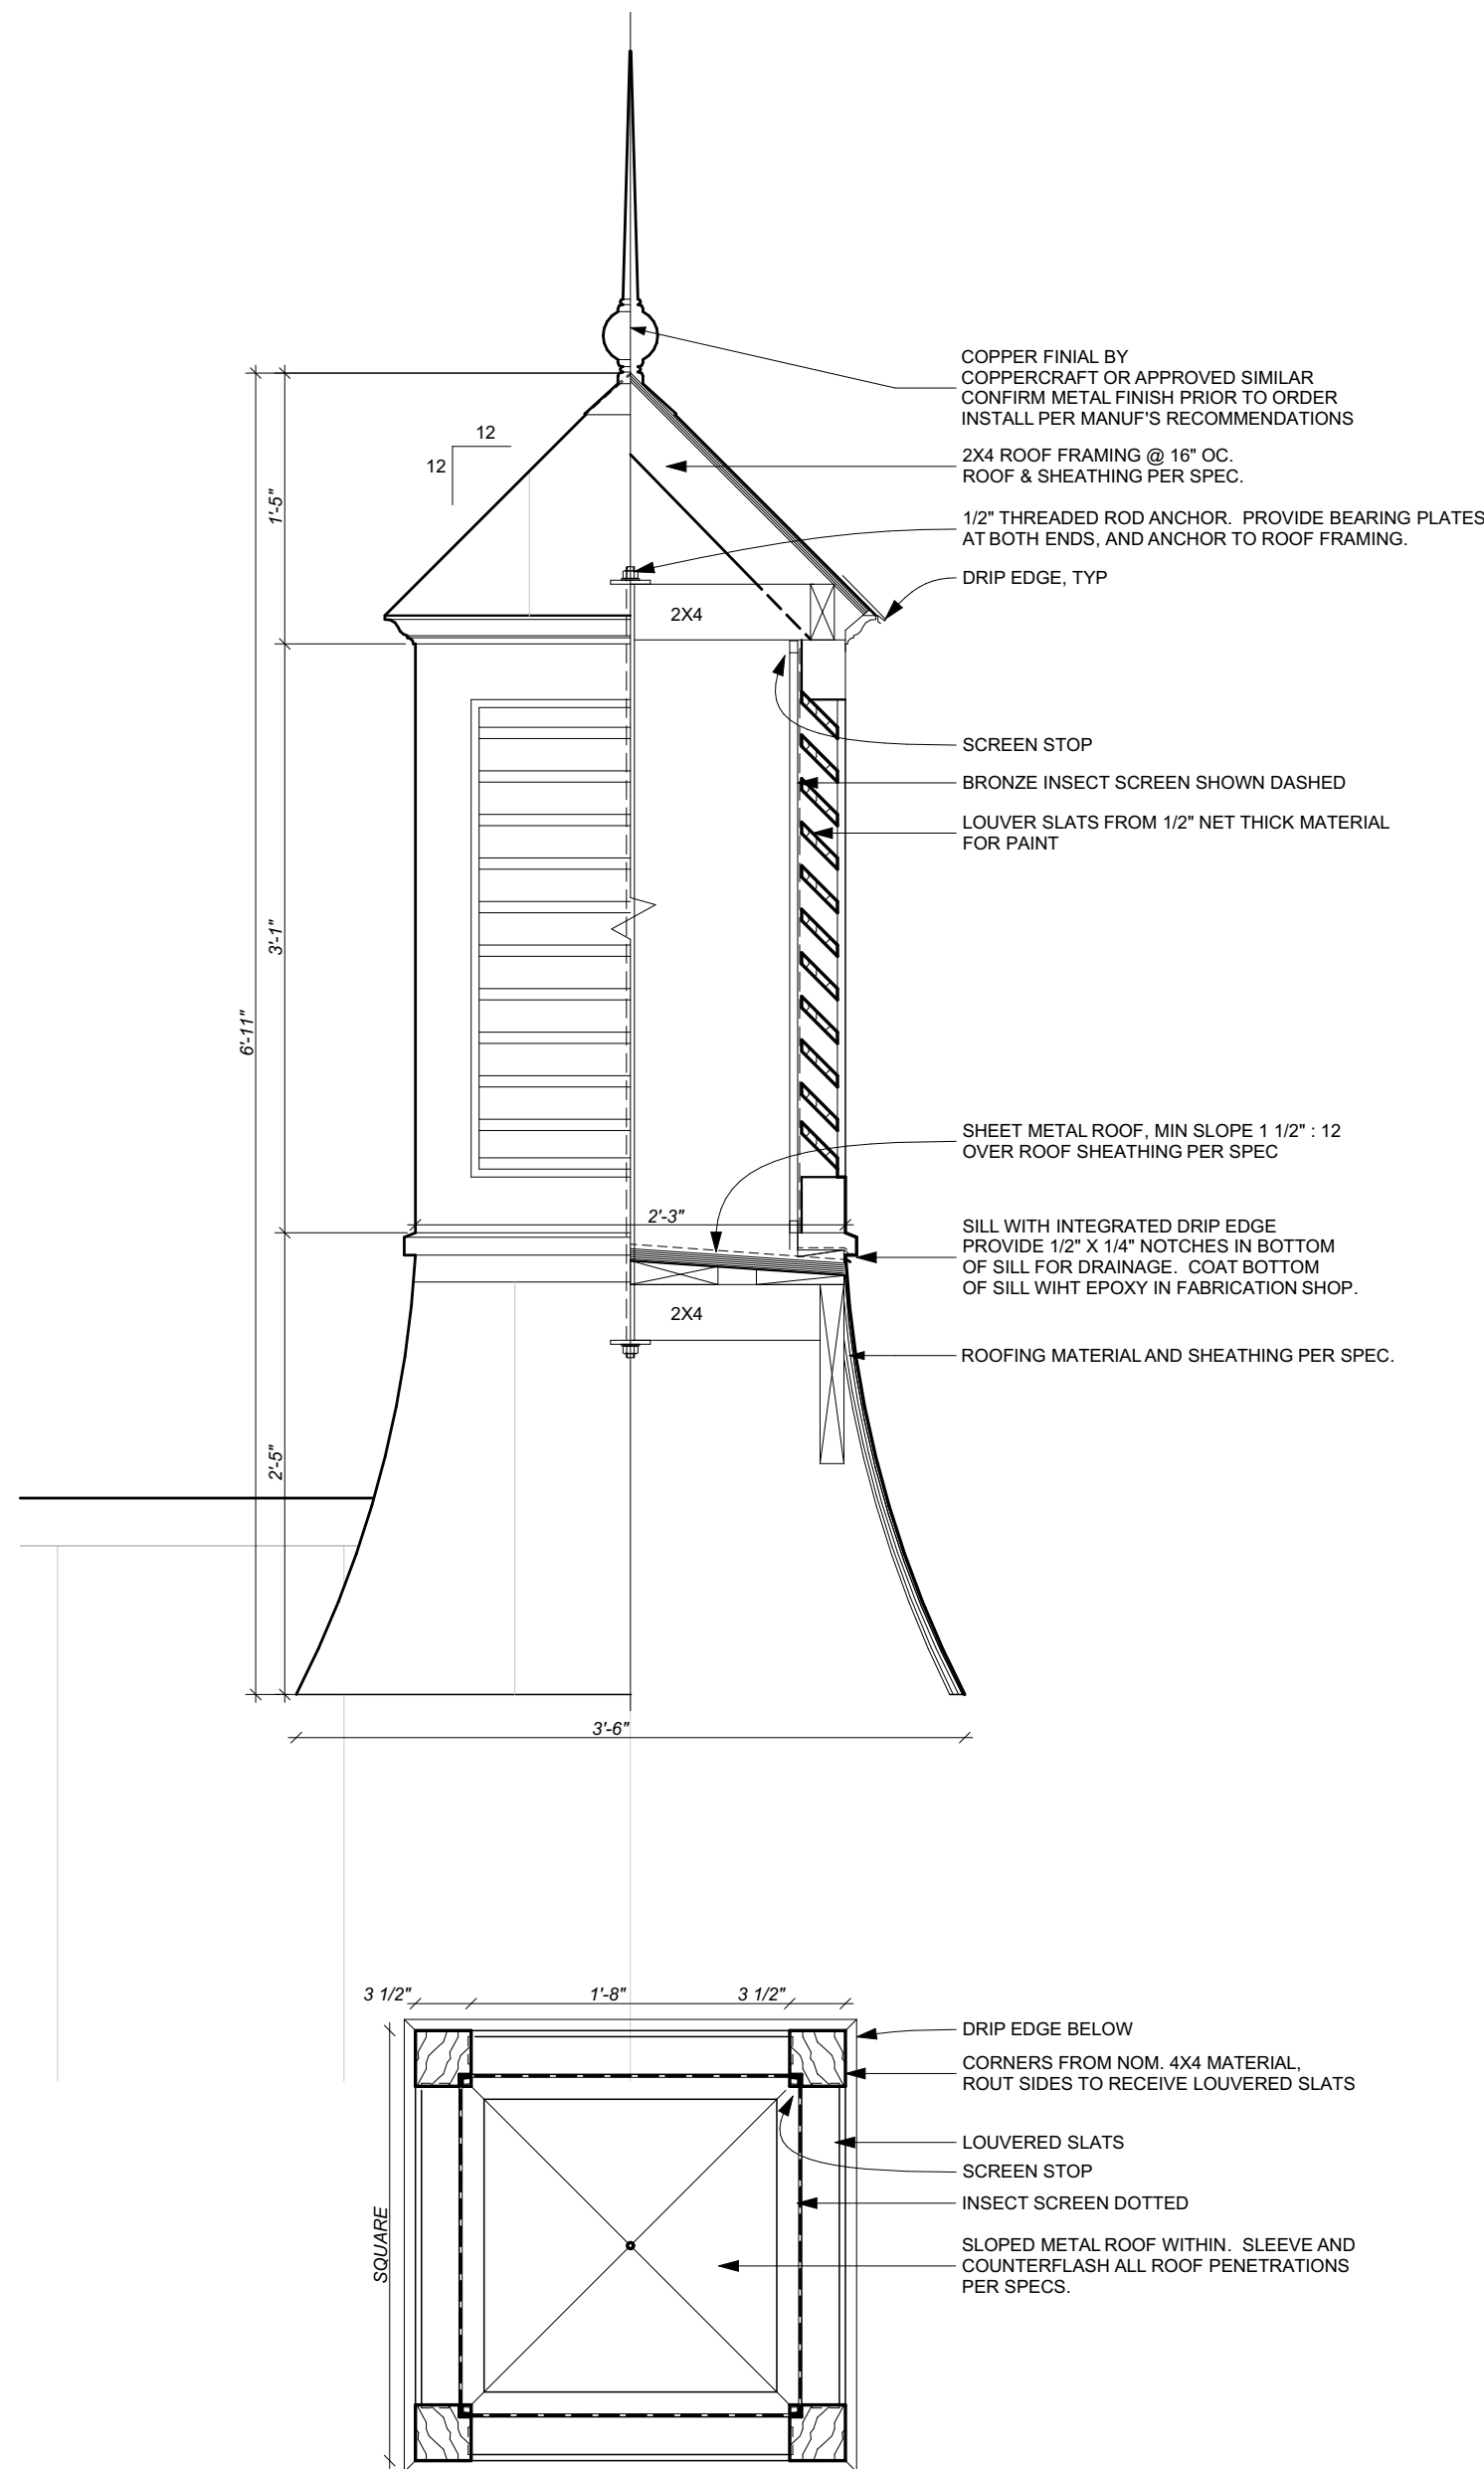

3 CUPOLA DETAIL - ADD ALTERNATE
SCALE: 1" = 1'-0"

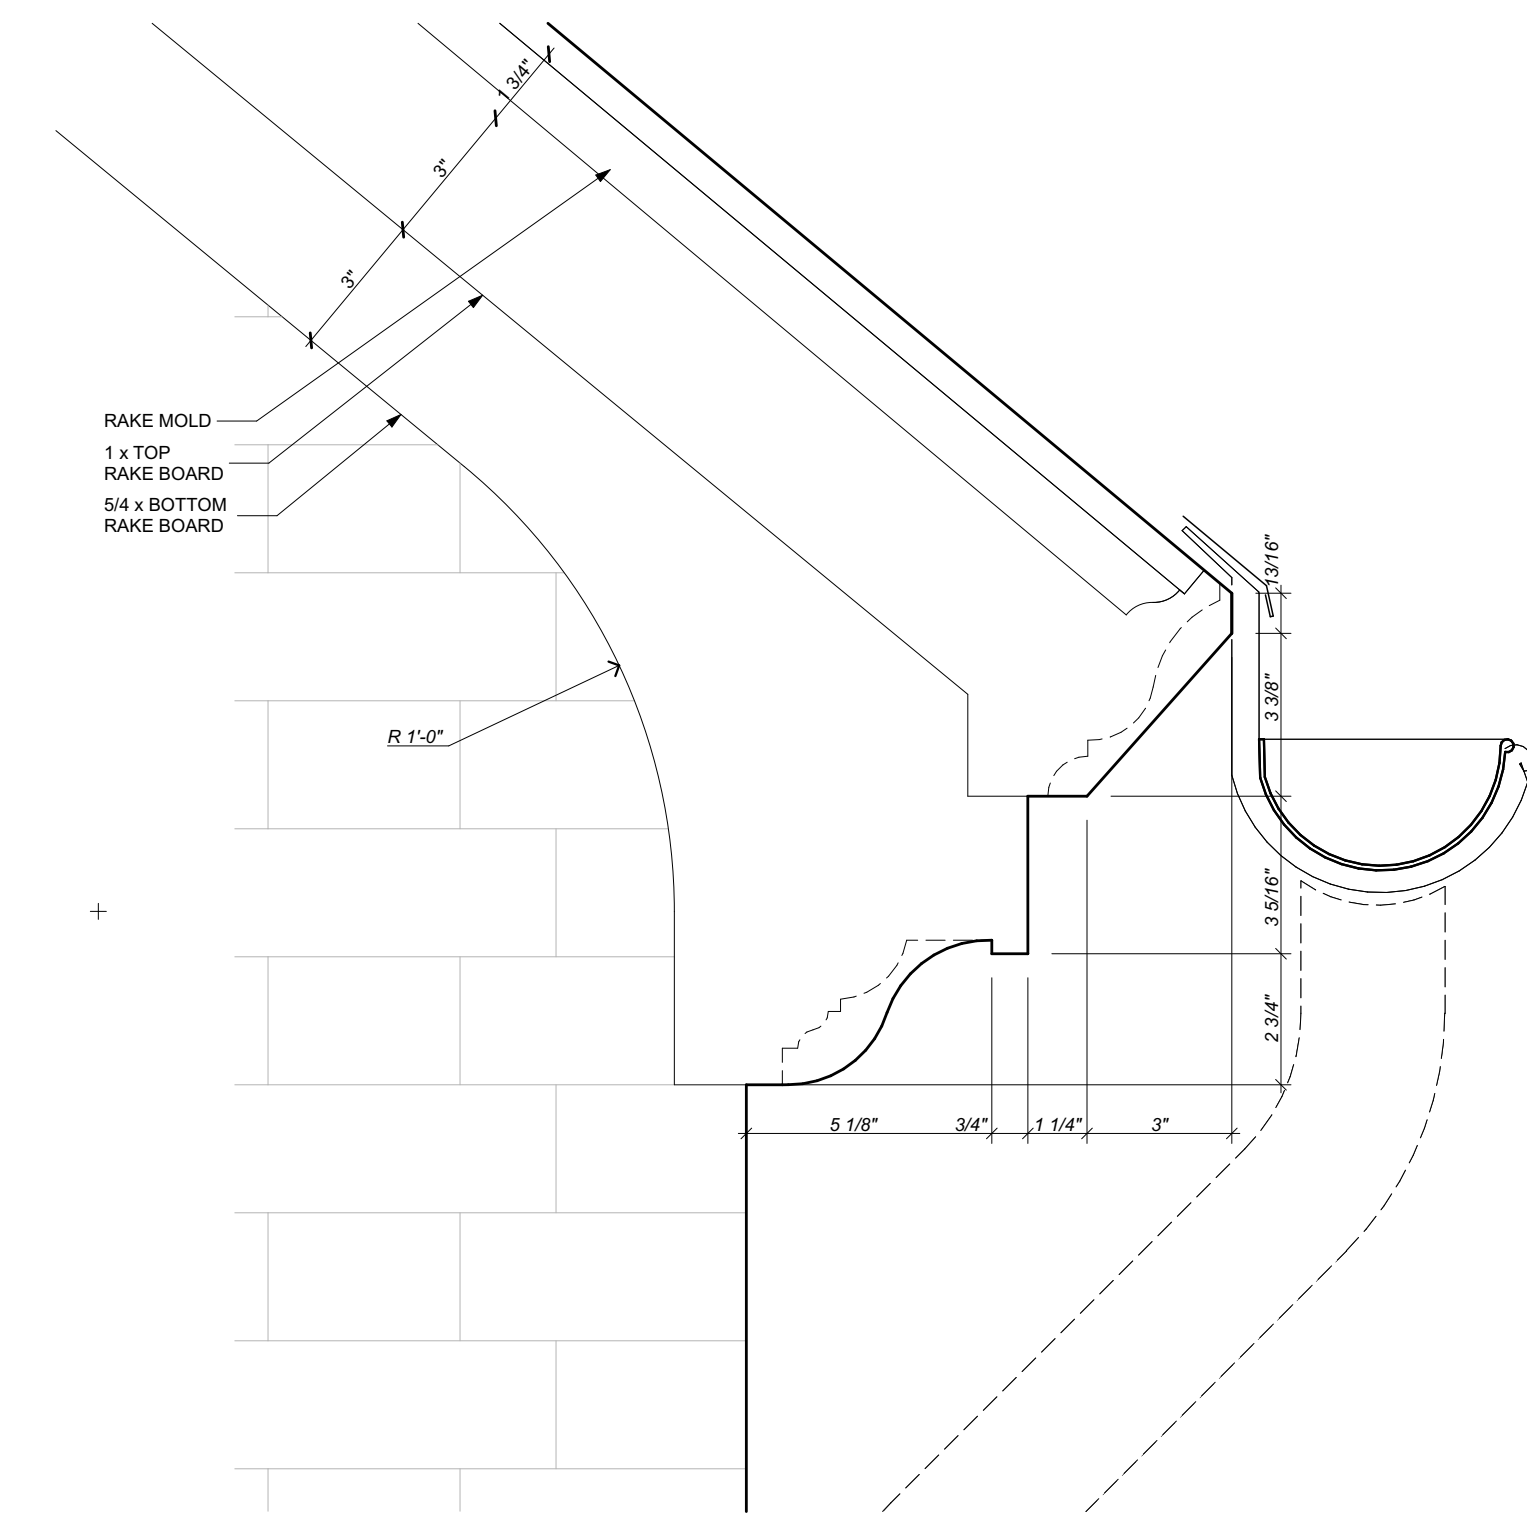


1 PORKCHOP EAVE DETAIL
SCALE: 3" = 1'-0"

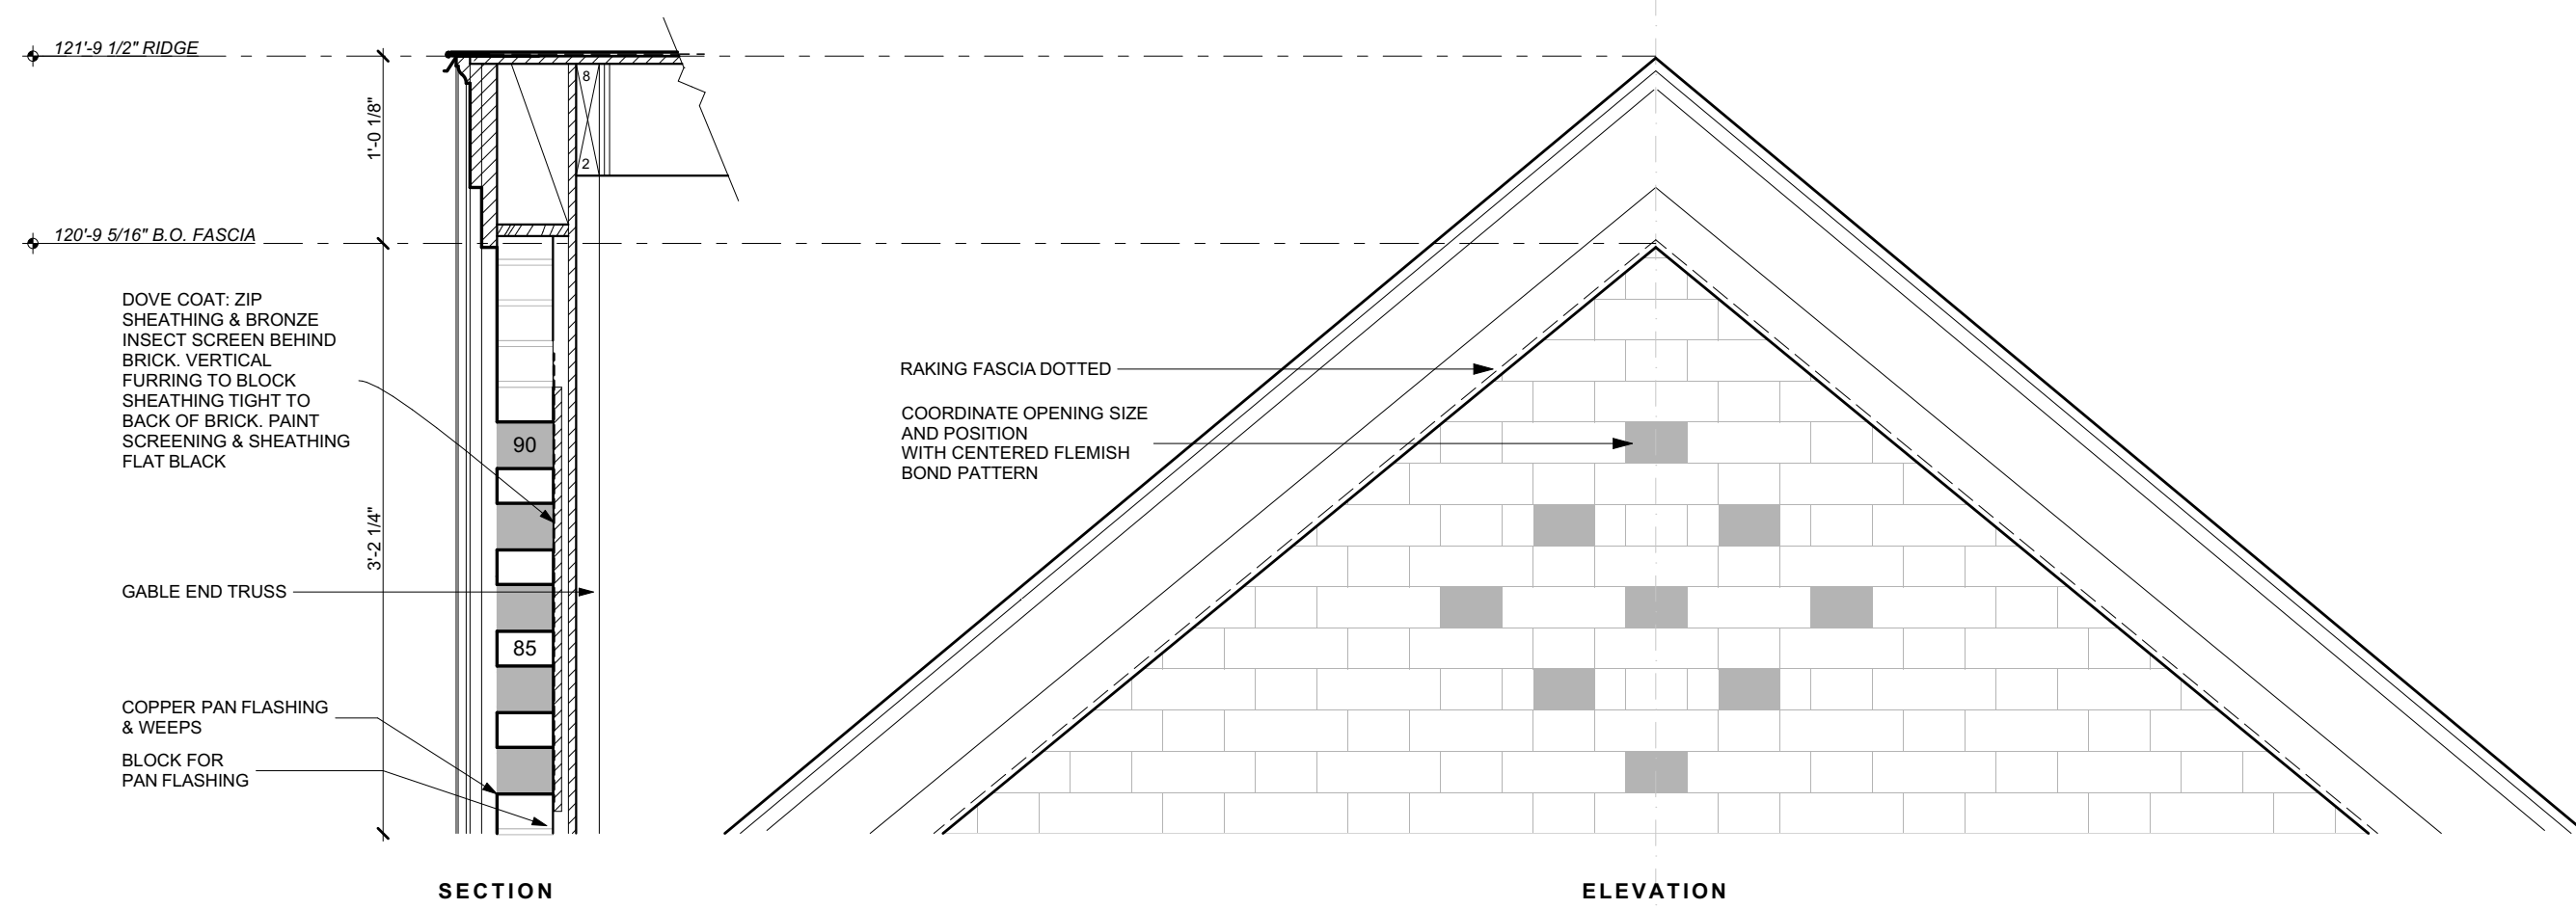

2 DOVECOTE DETAILS

FINISH SCHEDULE													
	ROOM		FLOOR	WALLS		TRIM					CEILING		
	NO	NAME		MATERIAL	FINISH	BASE	CHAIR RAIL	CASING	CROWN	FINISH	MATERIAL	FINISH	HEIGHT
FIRST FLOOR													
	100	GARAGE	CONC	GYP L3	PAINT	B-1	-	T-1	-	PAINT	GYP L3	PAINT	10'-0"


EXTERIOR DOOR SCHEDULE													
	MARK	MANUFACTURER	TYPE	LITES	FRAME SIZE			EXT SASH FINISH	EXT JAMB FINISH	INT FINISH	THRESHOLD	HARDWARE	REMARKS
					WIDTH	HEIGHT	JAMB DEPTH						
FIRST FLOOR													
	D01	MARVIN	PATIO OUT-SWING	REFER TO DRAWING	3'-0"	7'-0"	6 9/16"	CLAD	CLAD	PAINT	CONCRETE		
	G01	CLOPAY	GARAGE	REFER TO DRAWING	9'-0"	8'-0"	REFER TO DRAWINGS	CLAD	CLAD	PAINT	ASPHALT APRON	BLACK	
	G02	CLOPAY	GARAGE	REFER TO DRAWING	9'-0"	8'-0"	REFER TO DRAWINGS	CLAD	CLAD	PAINT	ASPHALT APRON	BLACK	

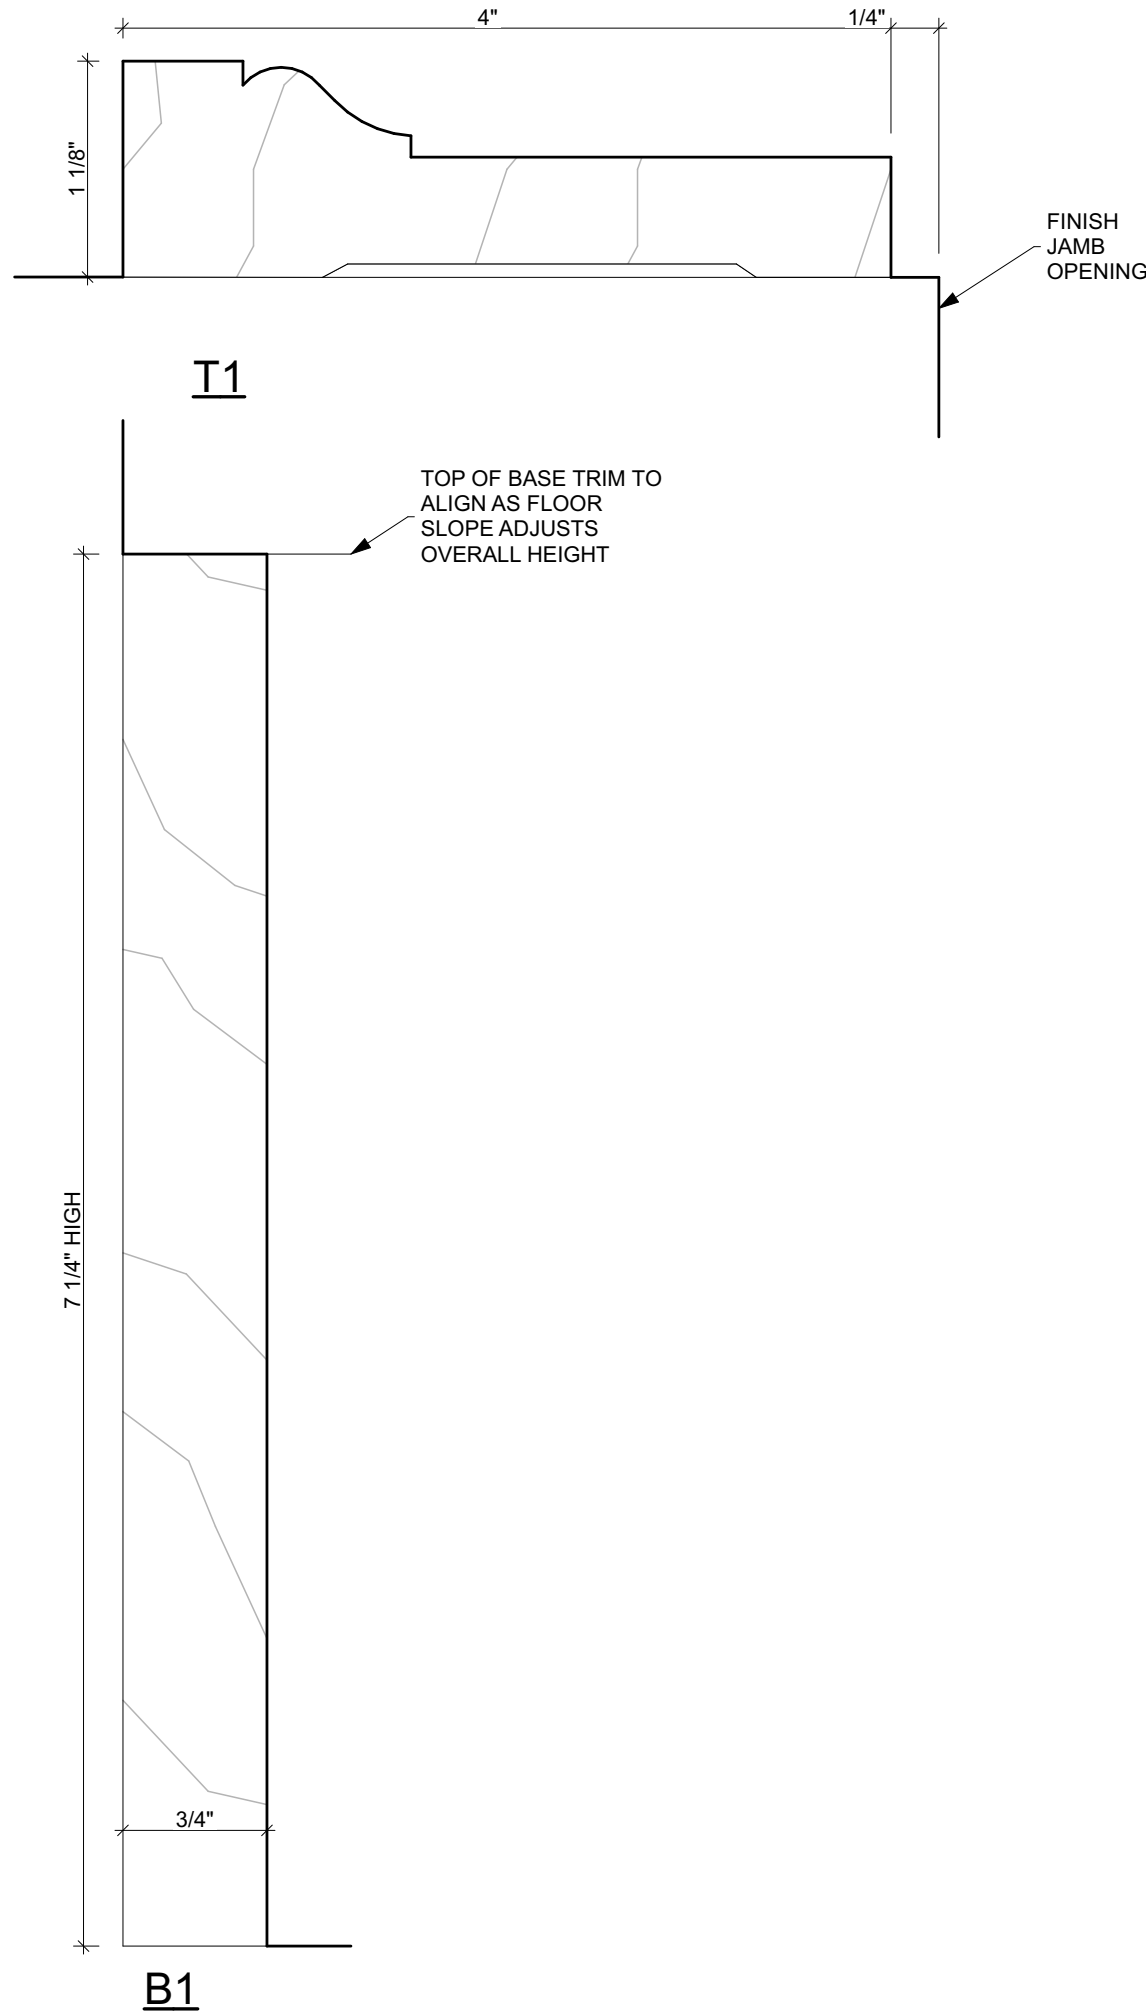

Revisions	
Release	Date
01	1/13/2023
02	2/6/2023

Job #	Date
4504.1	06 FEB 2023
Drawn	Checked
DRG	EWA
CONTRACTOR TO VERIFY ALL DIMENSIONS AT SITE AND SHALL NOTIFY ARCHITECT OF ANY DISCREPANCIES BEFORE PROCEEDING	
© 2021 Dalgliesh Gilpin Paxton Architects	
A-400	

PRINTED 2/6/2023, 4:49 PM

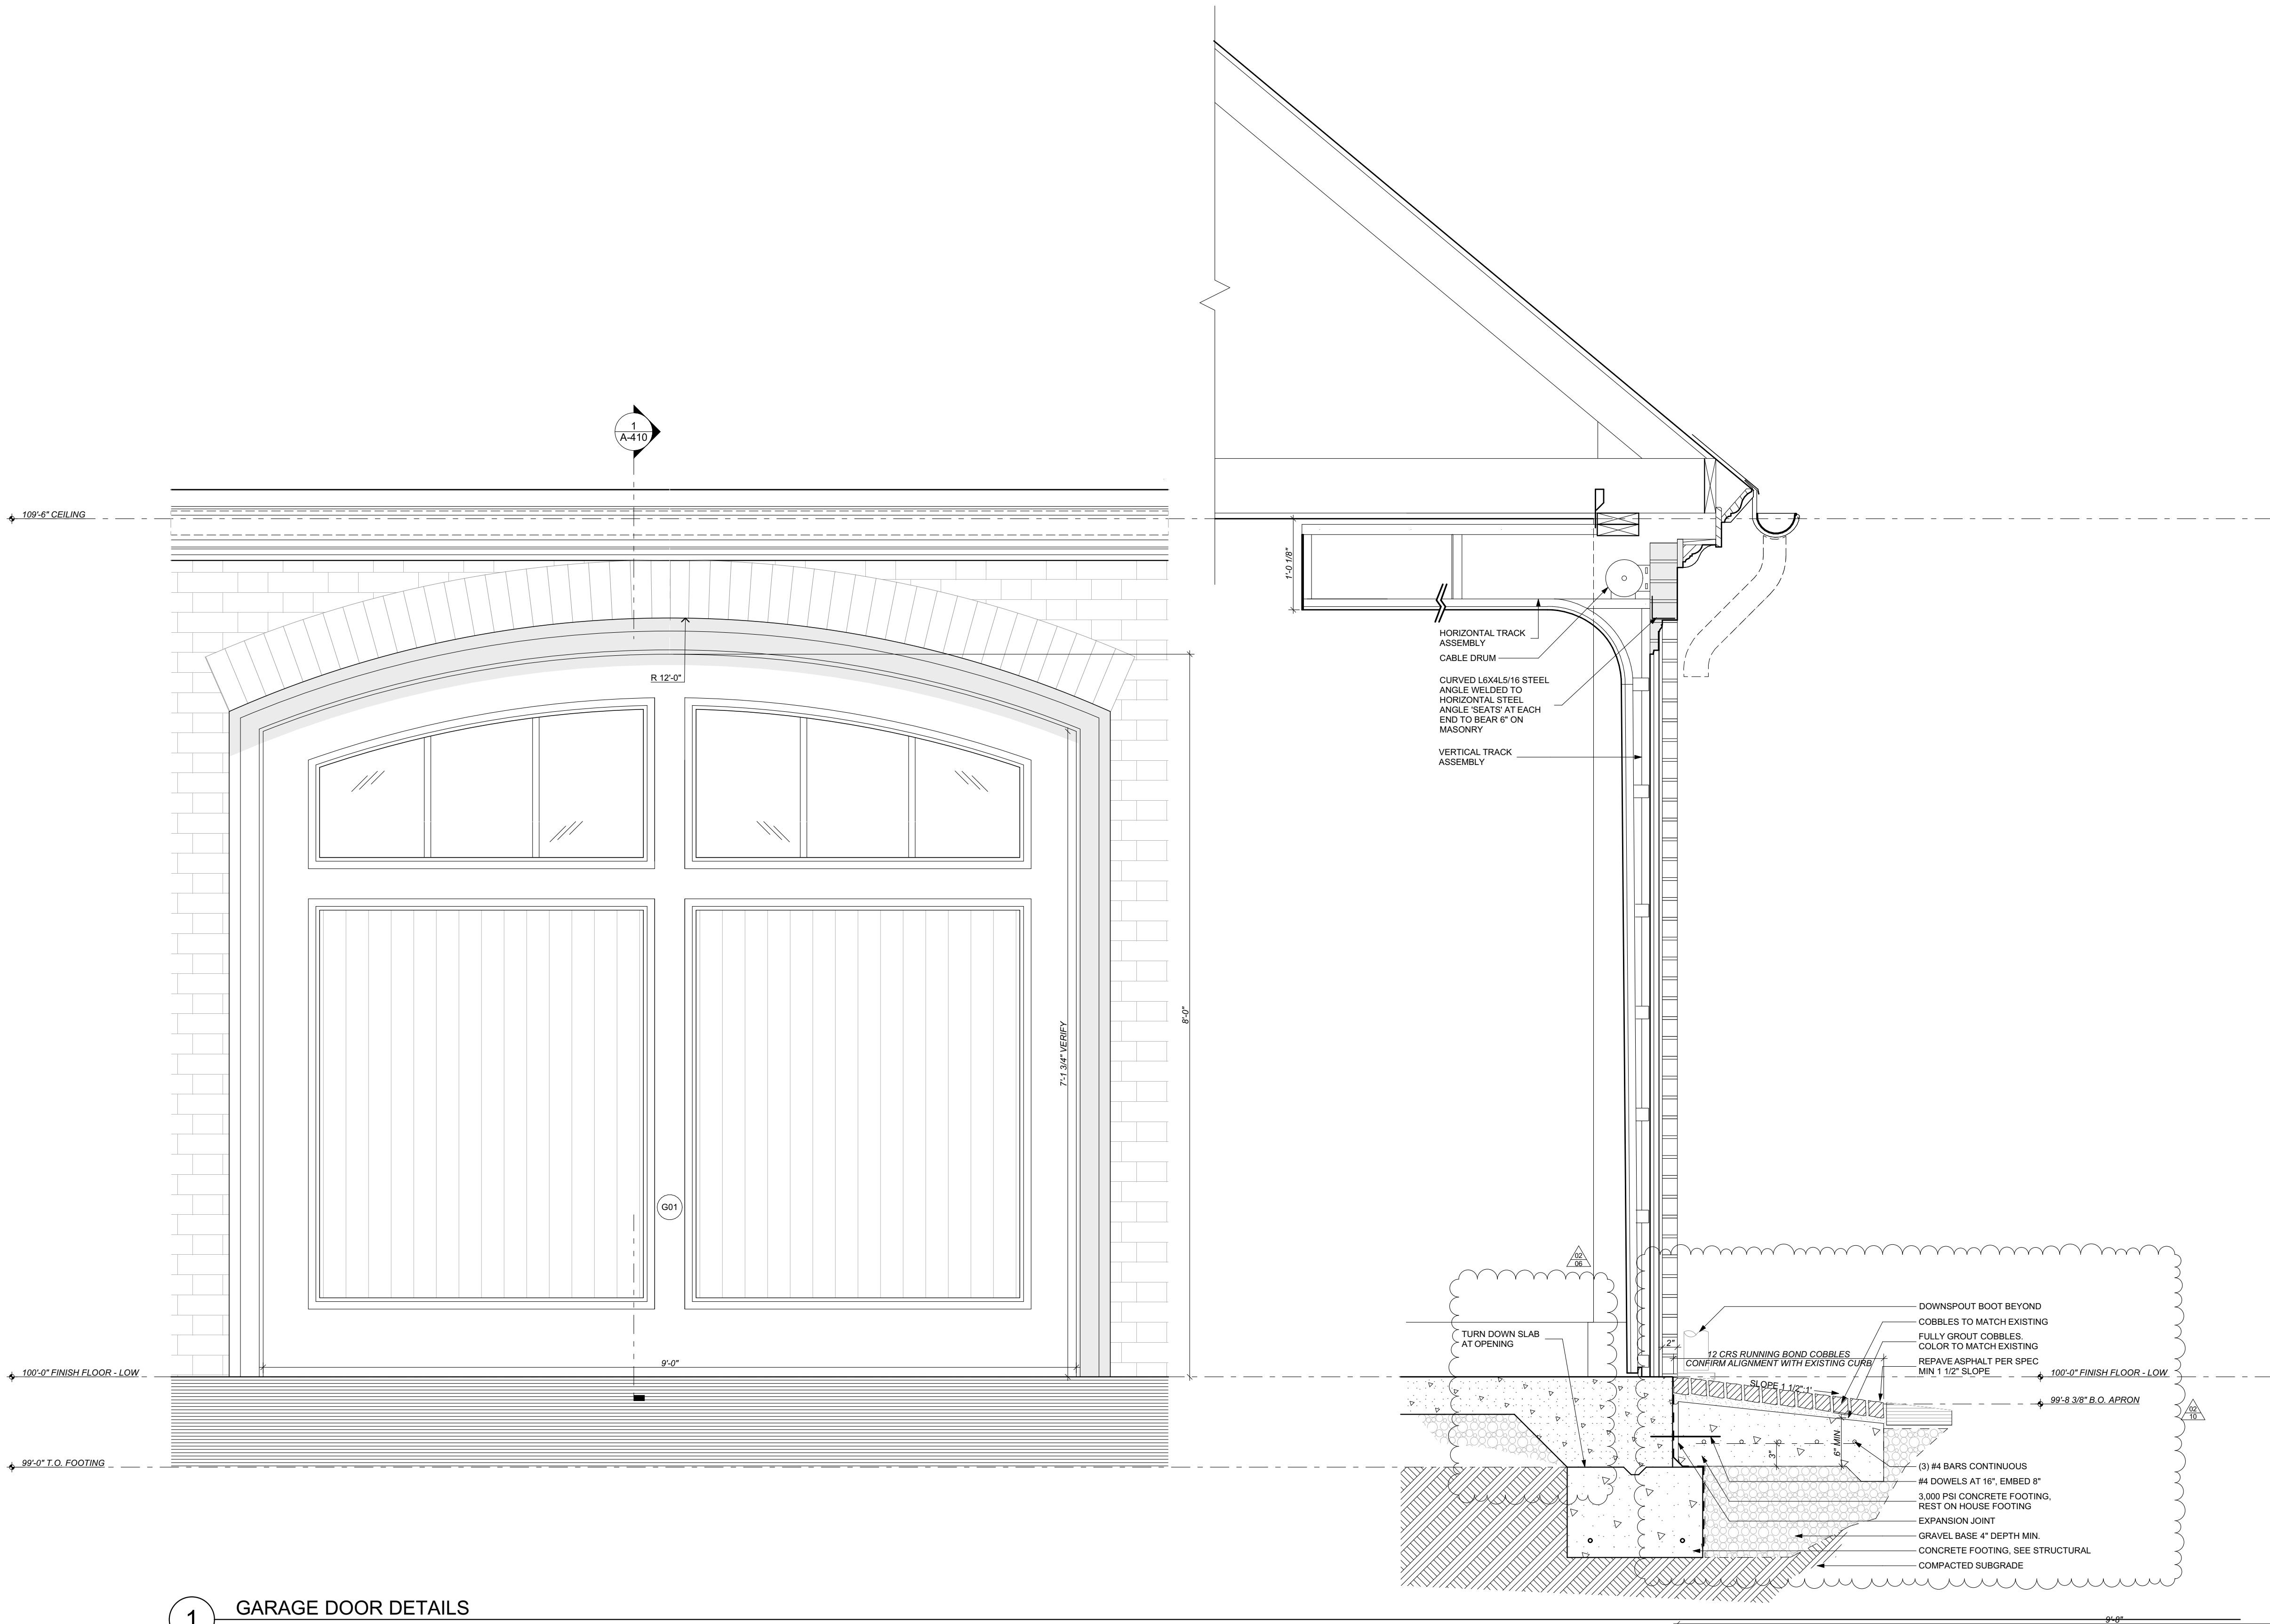

1 GARAGE DOOR DETAILS
SCALE: 1" = 1'-0"

DALGLIESH
GILPIN
PAXTON

ARCHITECTS

Tivoli Farm - Garage
9171 Tivoli Drive
Gordonsville, VA

GARAGE DOOR DETAILS
CONSTRUCTION DOCUMENTS

Revisions	
Release	Date
01	1/13/2023
02	2/6/2023

Job #	Date
4504.1	06 FEB 2023


Drawn	Checked
DRG	EWA

CONTRACTOR TO VERIFY ALL DIMENSIONS AT SITE AND SHALL NOTIFY ARCHITECT OF ANY DISCREPANCIES BEFORE PROCEEDING


© 2021 Dalgliesh Gilpin Paxton Architects

A-410

02 - Construction Documents: 2/6/2023

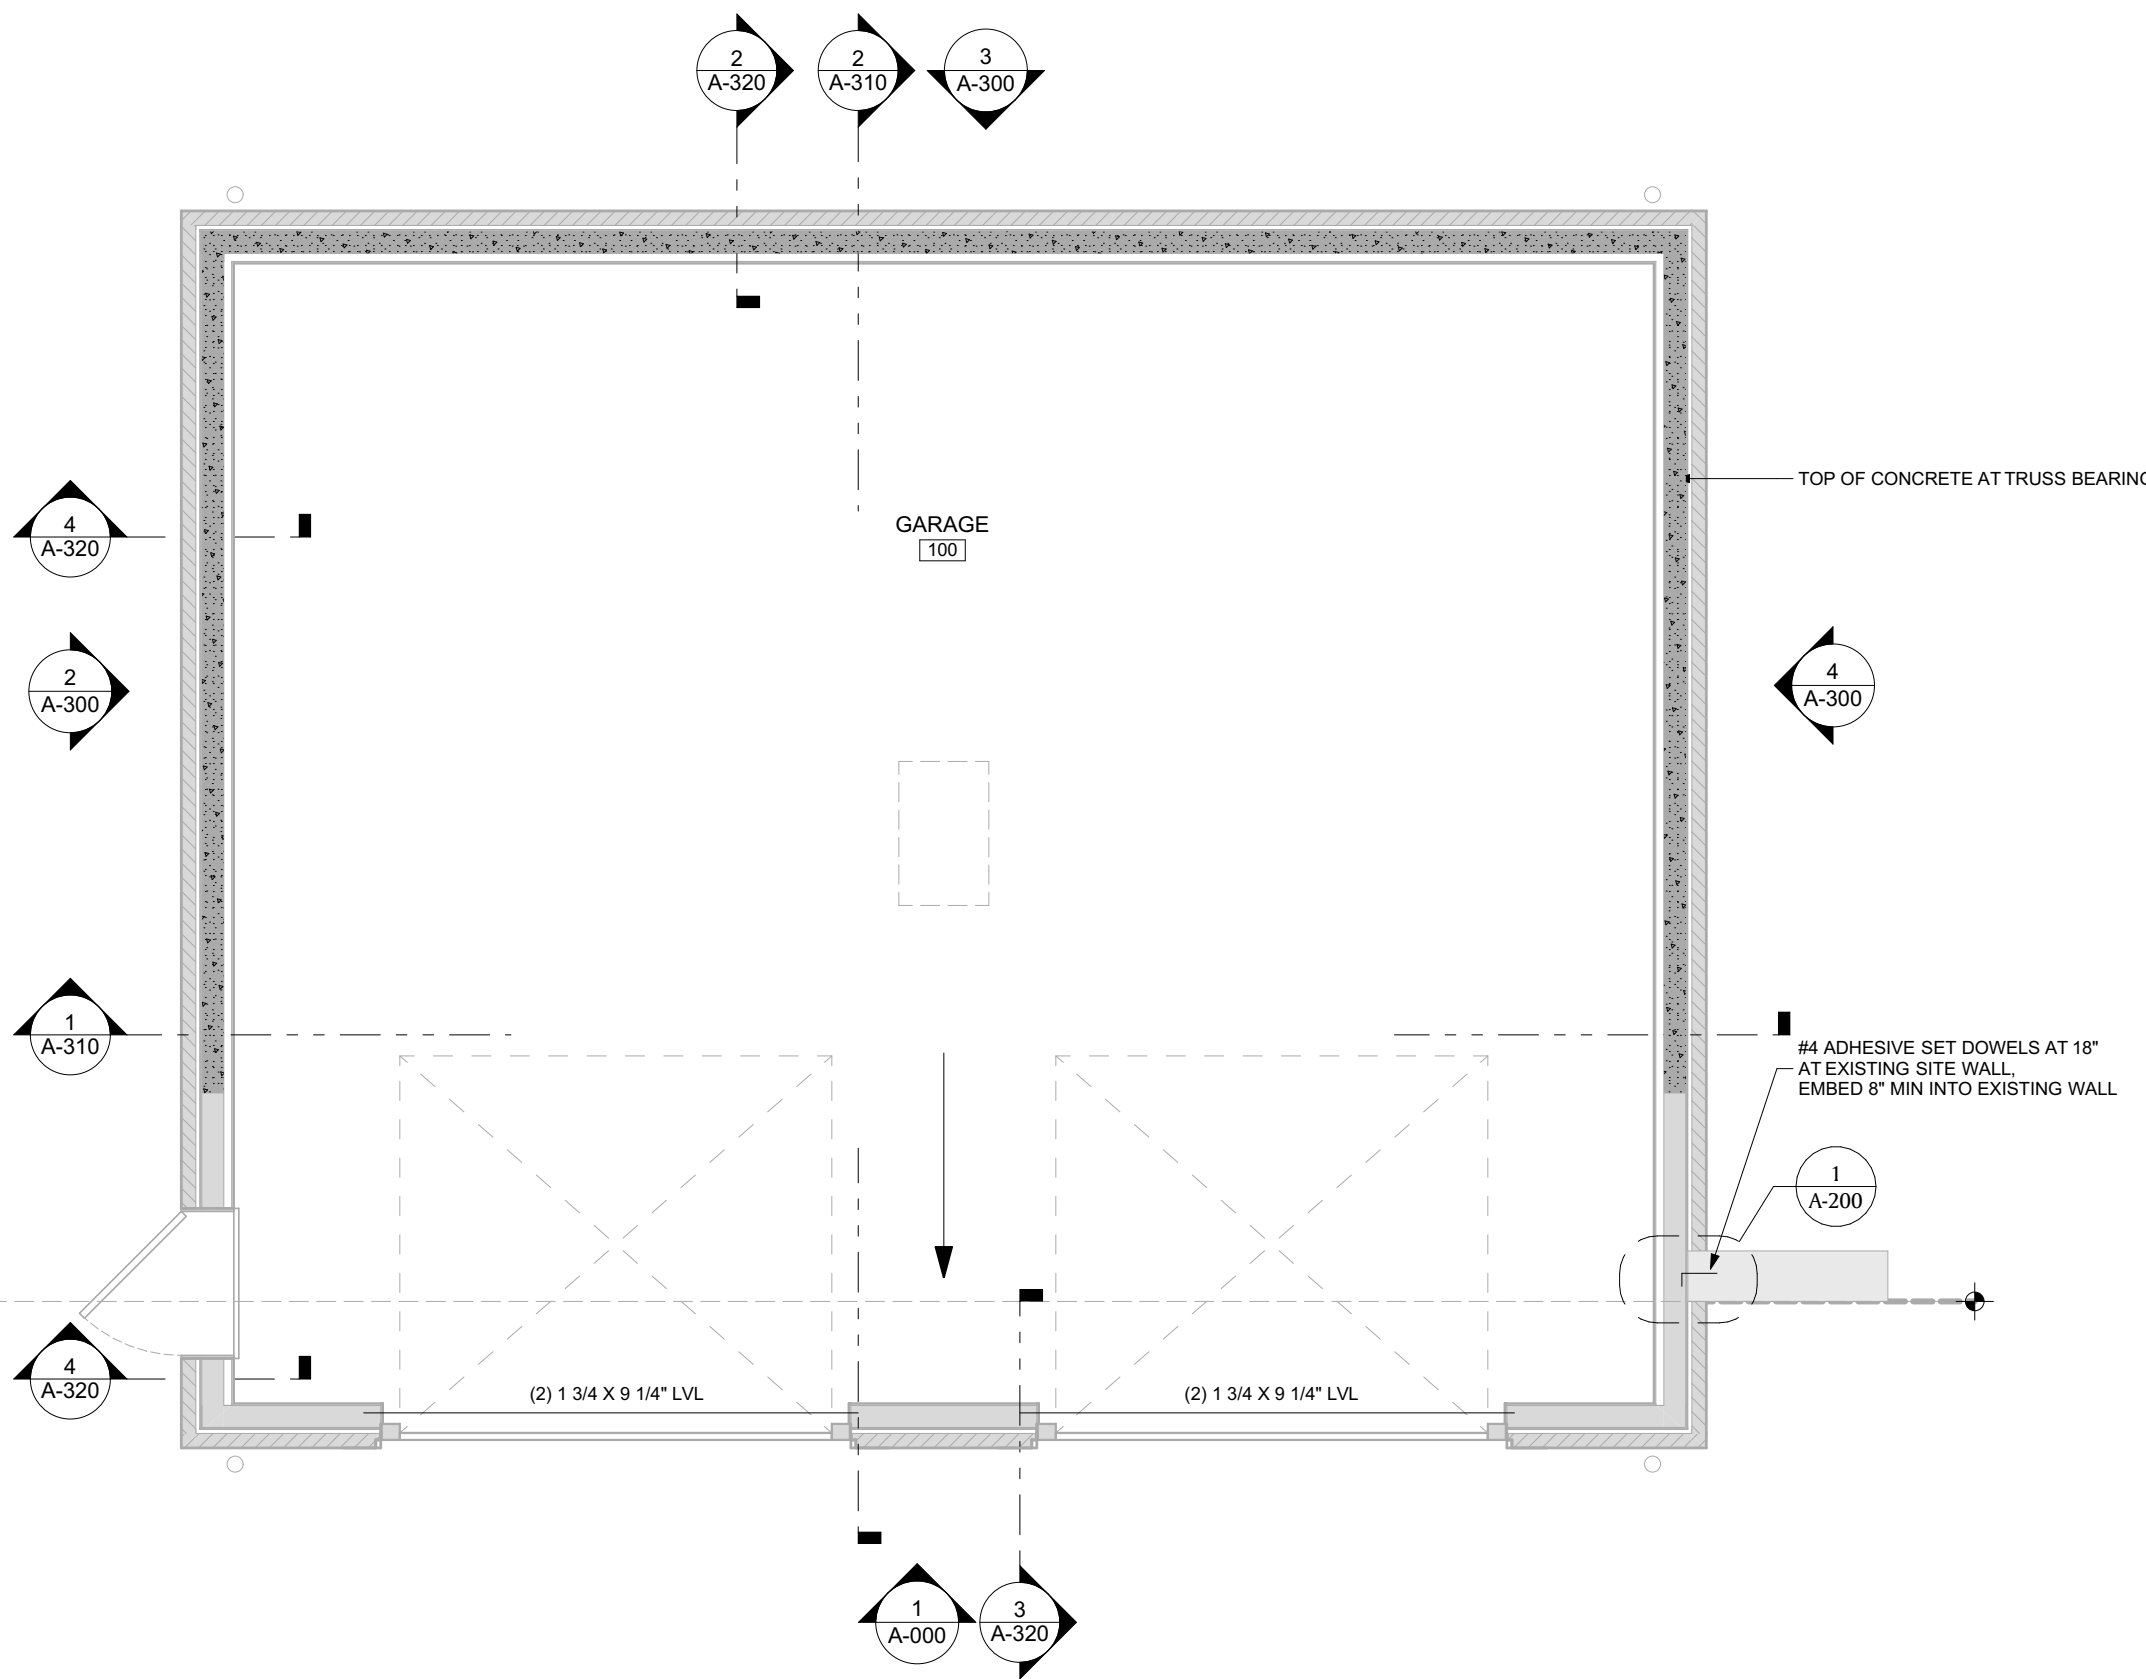

1 FIRST FLOOR - STRUCTURAL
SCALE: 1/4" = 1'-0"

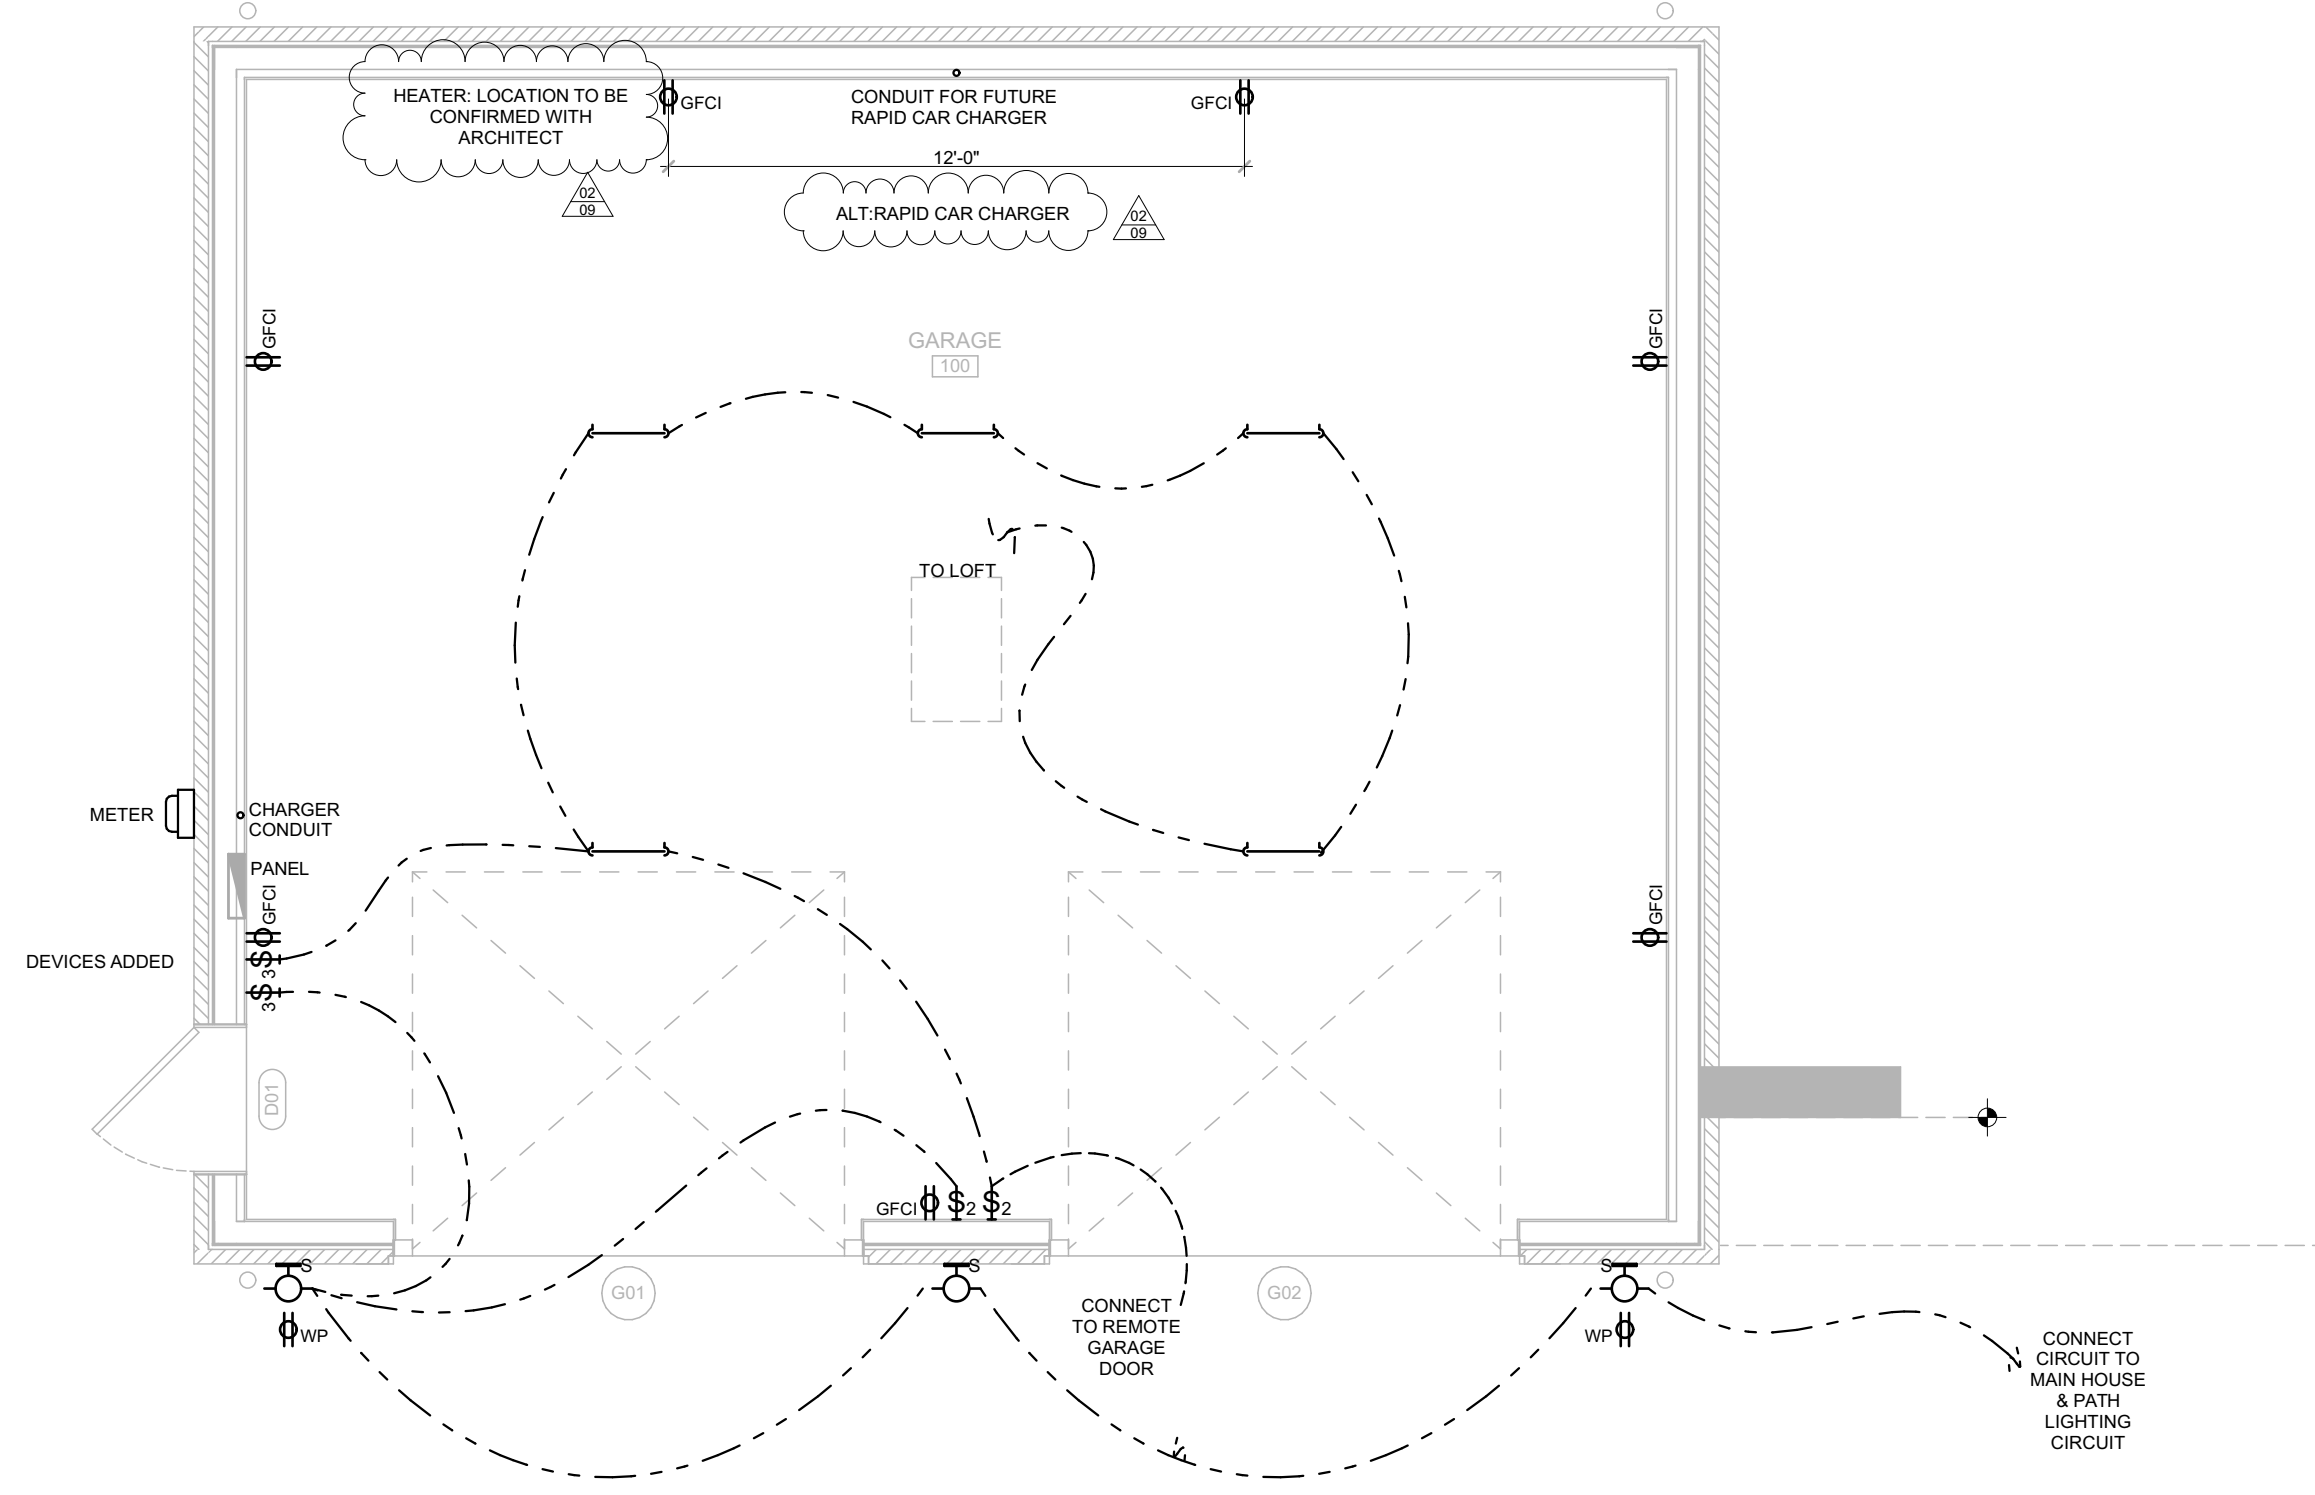

2 FIRST FLOOR - ELECTRICAL
SCALE: 1/4" = 1'-0"

TIVOLI FARM - GARAGE - ELECTRICAL PLANS

KEY

TO BE DEMOLISHED

EXISTING TO REMAIN

NEW BUILDING CONSTRUCTION

NORTH

GENERAL ELECTRICAL NOTES

1. ALL FIXTURE, SWITCH AND OUTLET LOCATION TO BE REVIEWED ON-SITE WITH OWNER AND ARCHITECT PRIOR TO WIRING.

2. OUTLETS AND POWER FOR EQUIPMENT AS REQUIRED AND BY CODE

ELECTRICAL SYMBOLS

UNDERCABINET FIXTURE

LINEAR FIXTURE

RECESSED CEILING FIXTURE

SCENCE

SWITCH

JAMB SWITCH

TIMER CONTROLLED FAN

VENT

TELEVISION (2) R06D & (3) CAT6

DATAPOINT

GFCI OUTLET

WATERPROOF OUTLET

FLOOR OUTLET - ELEC OR TEL

Revisions	
Release	Date
01	1/19/2023
02	2/6/2023

Job #	Date
4504.1	06 FEB 2023
Drawn	Checked
DRG	EWA

CONTRACTOR TO VERIFY ALL DIMENSIONS AT SITE AND SHALL NOTIFY ARCHITECT OF ANY DISCREPANCIES BEFORE PROCEEDING